


MENTOR

RESEARCH IN MOTION CONFIDENTIAL

HIERARCHICAL BLOCK		COPYRIGHT 2008, RESEARCH IN MOTION LIMITED	
MAIN		295 PHILLIP ST.	
DRAWN BY Steve Wellington		WATERLOO, ONTARIO, CANADA	
R&D CHECK		PHONE: (519) 888-7465, FAX (519) 888-6306	
RFG CHECK		TITLE	
Edi Led Bu: swellington		Thunder	
Last Ed: 1 Sep 3, 2008, 1:18:13 pm		(Uses: PCB-17073-006)	
SIZE		DRAWING No. SCH-20983-001	
C		REV 1 SHEET 1 OF 20	

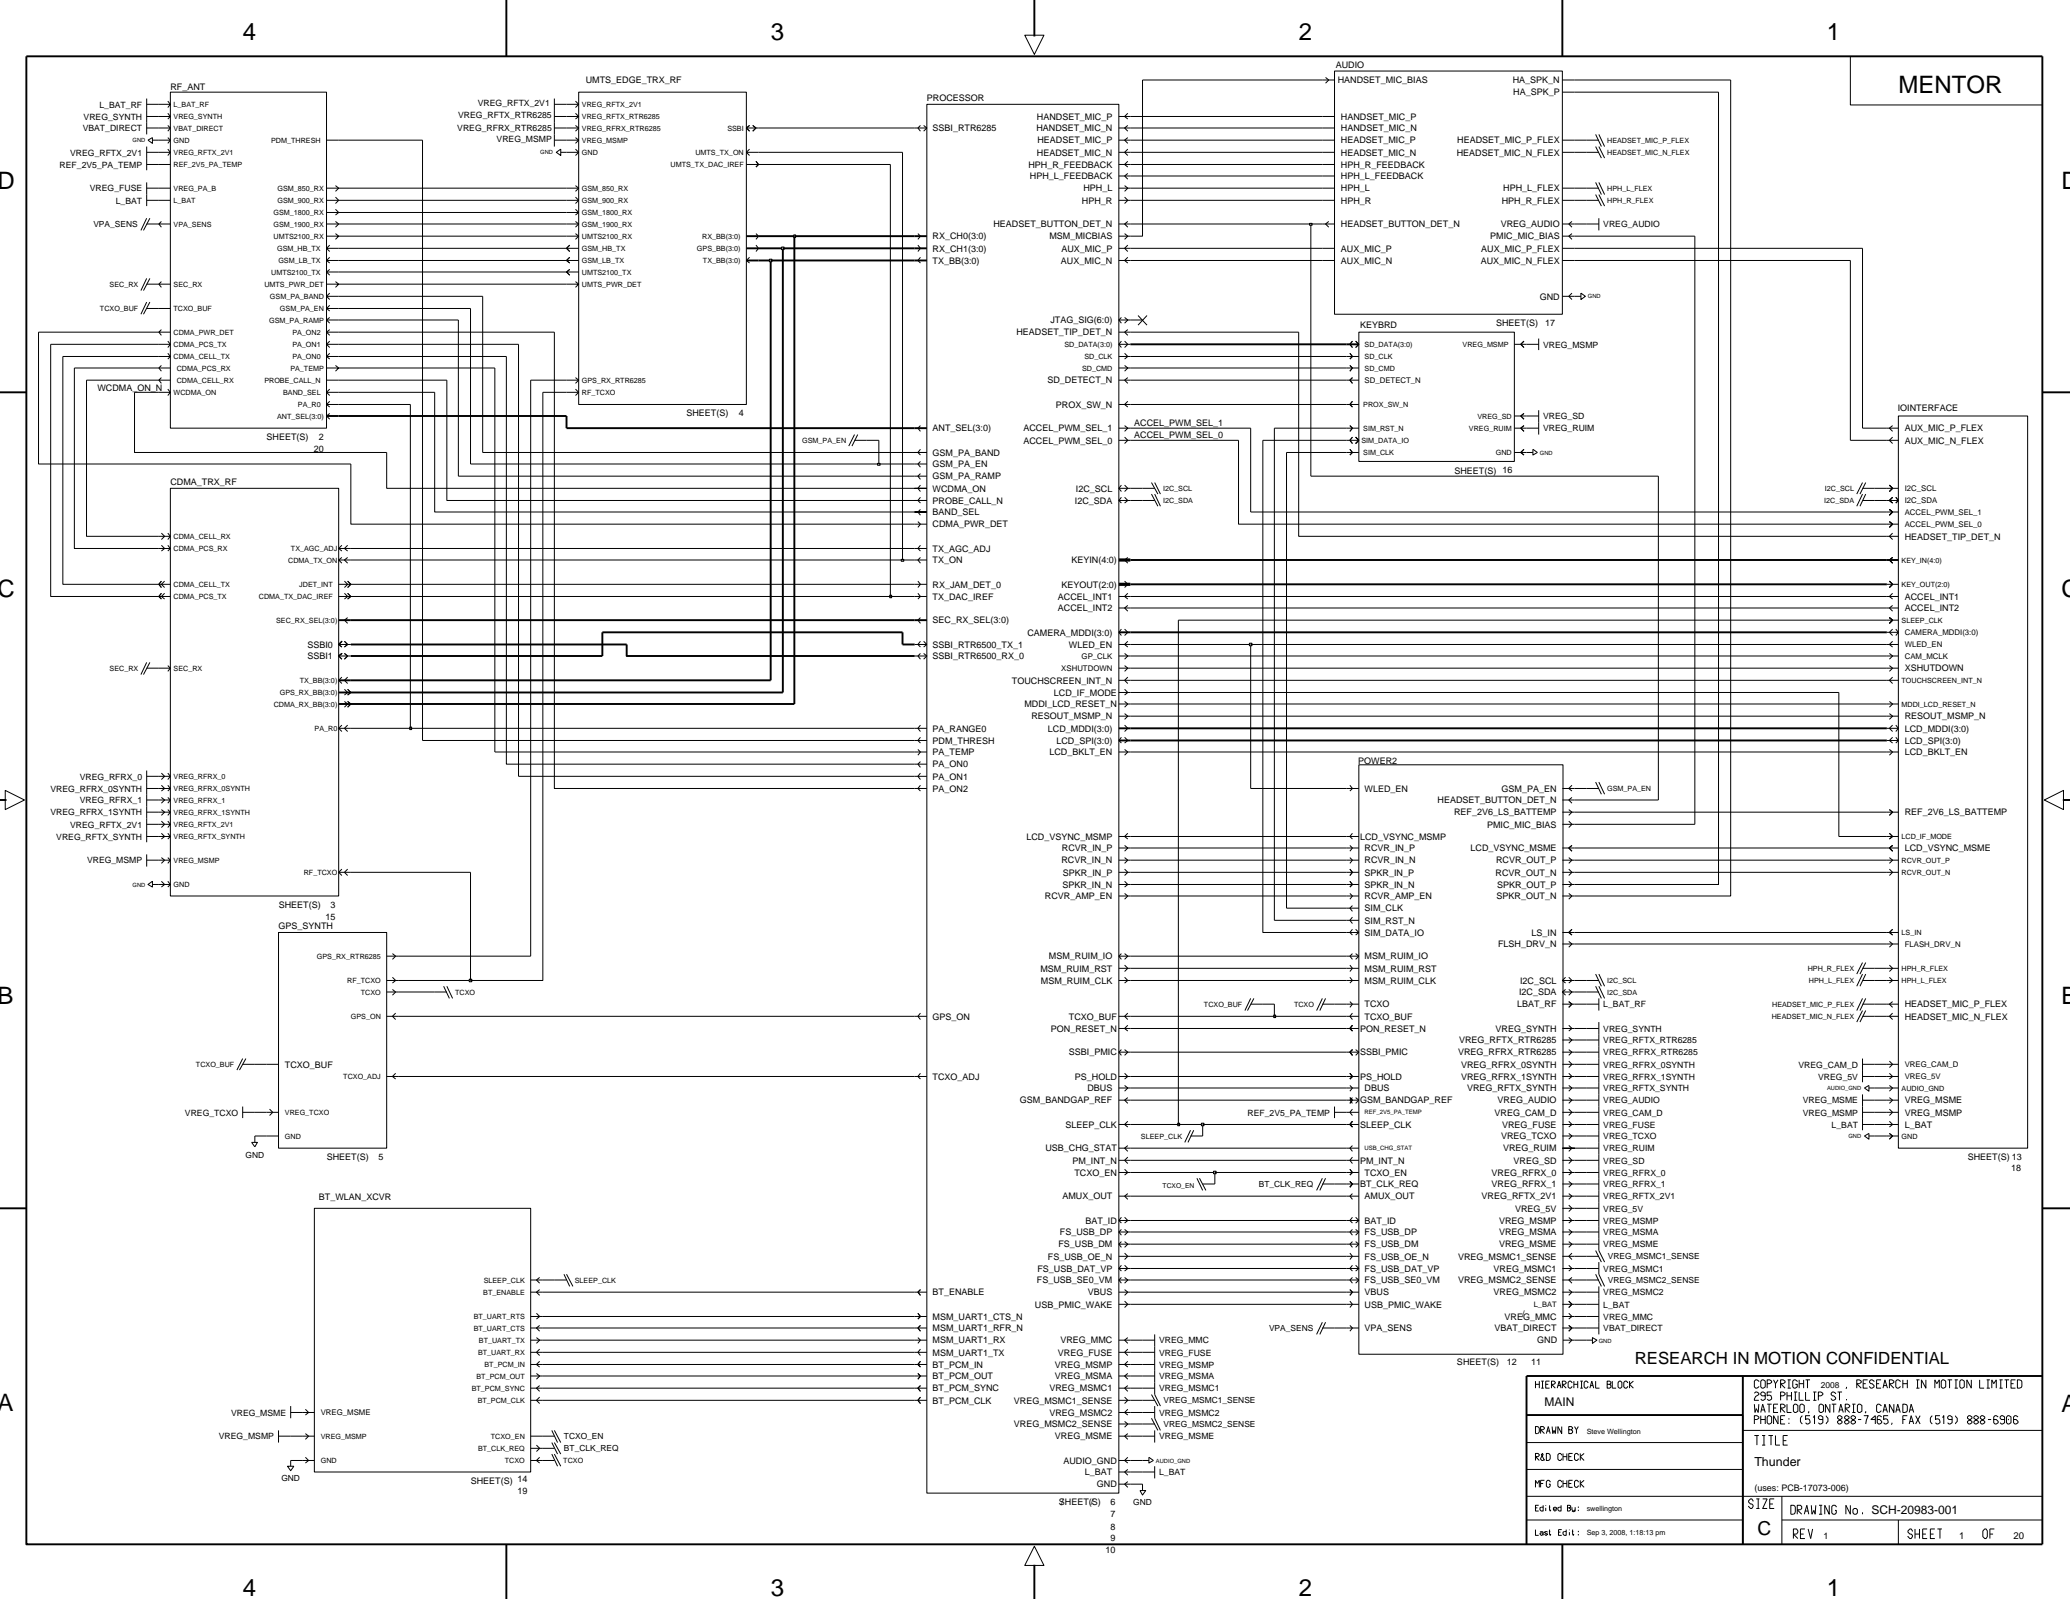

D

D

C


C

B

B

A

A

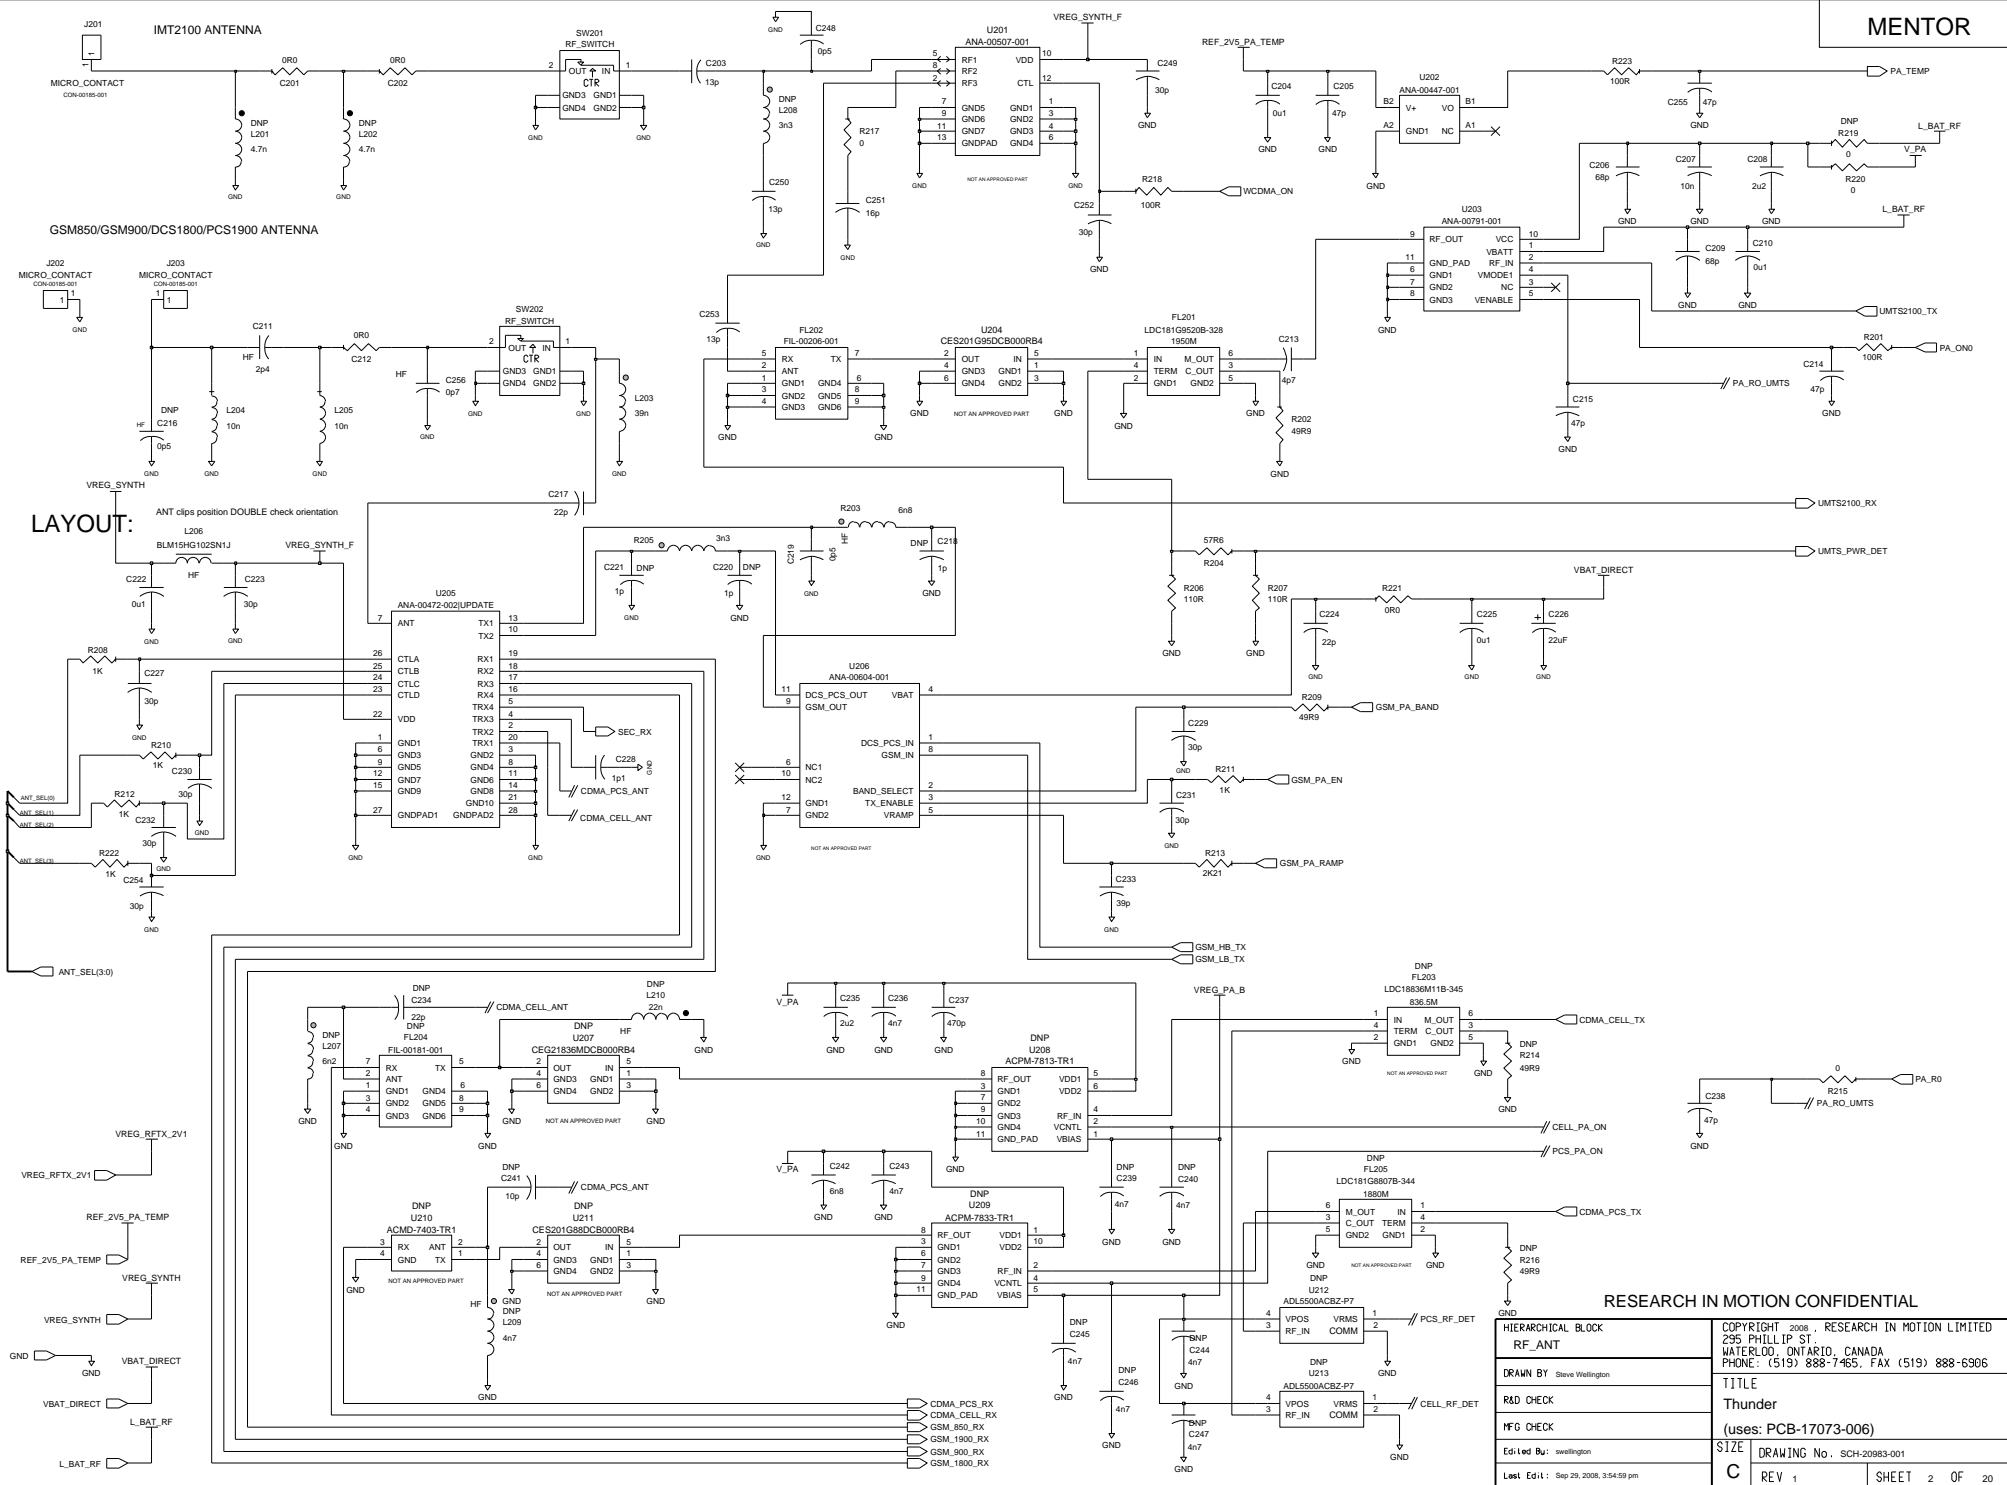

LAYOUT: ANT clips position DOUBLE check orientation

RESEARCH IN MOTION CONFIDENTIAL

HIERARCHICAL BLOCK		COPYRIGHT 2008, RESEARCH IN MOTION LIMITED 295 PHILLIP ST. WATERLOO, ONTARIO, CANADA PHONE: (519) 888-7465, FAX (519) 888-6306	
DRAWN BY Steve Wellington		TITLE Thunder	
R&D CHECK		IFG CHECK	
Edi Led Bu: swellington		SIZE DRAWING No. SCH-20983-001	
Last Ed: 1 Sep 29, 2008, 3:54:59 pm		C REV 1 SHEET 2 OF 20	

D

D

C


C

B

B


A

A

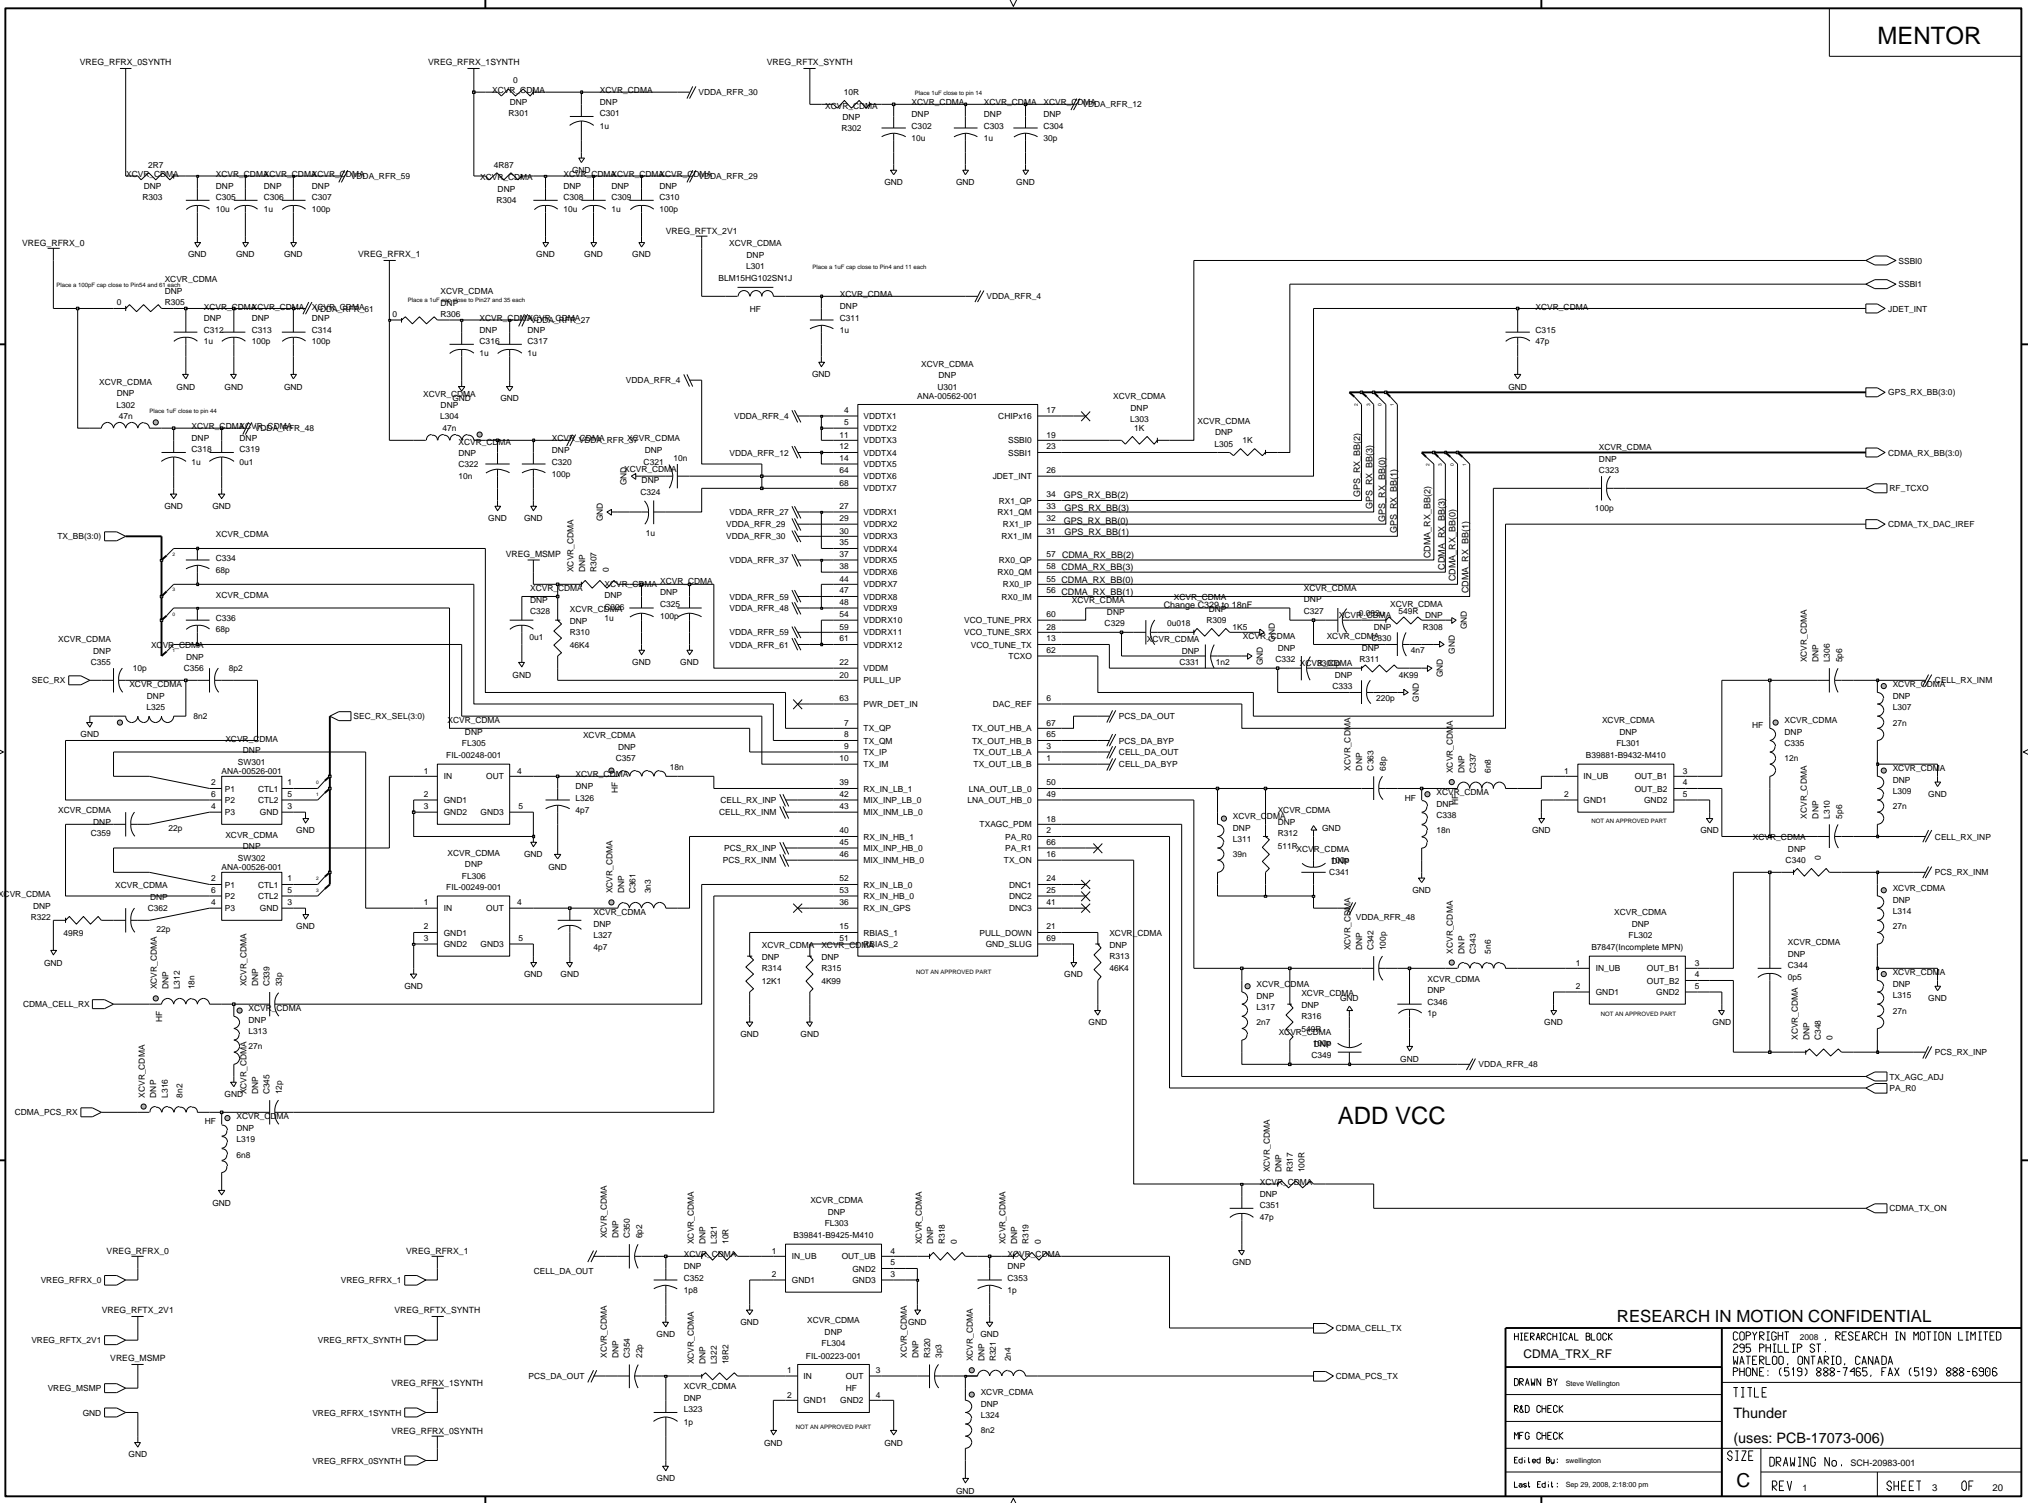

ADD VCC


HIERARCHICAL BLOCK CDMA_TRX_RF		RESEARCH IN MOTION CONFIDENTIAL	
DRAWN BY: Steve Wellington		COPYRIGHT 2008, RESEARCH IN MOTION LIMITED 295 PHILLIP ST. WATERLOO, ONTARIO, CANADA PHONE: (519) 888-7465, FAX (519) 888-6306	
R&D CHECK		TITLE Thunder	
MFG CHECK		(uses: PCB-17073-006)	
Edi Led By: swellington		SIZE DRAWING No. SCH-20983-001	
Last Ed: 1 Sep 29, 2008, 2:18:00 pm		C REV 1 SHEET 3 OF 20	

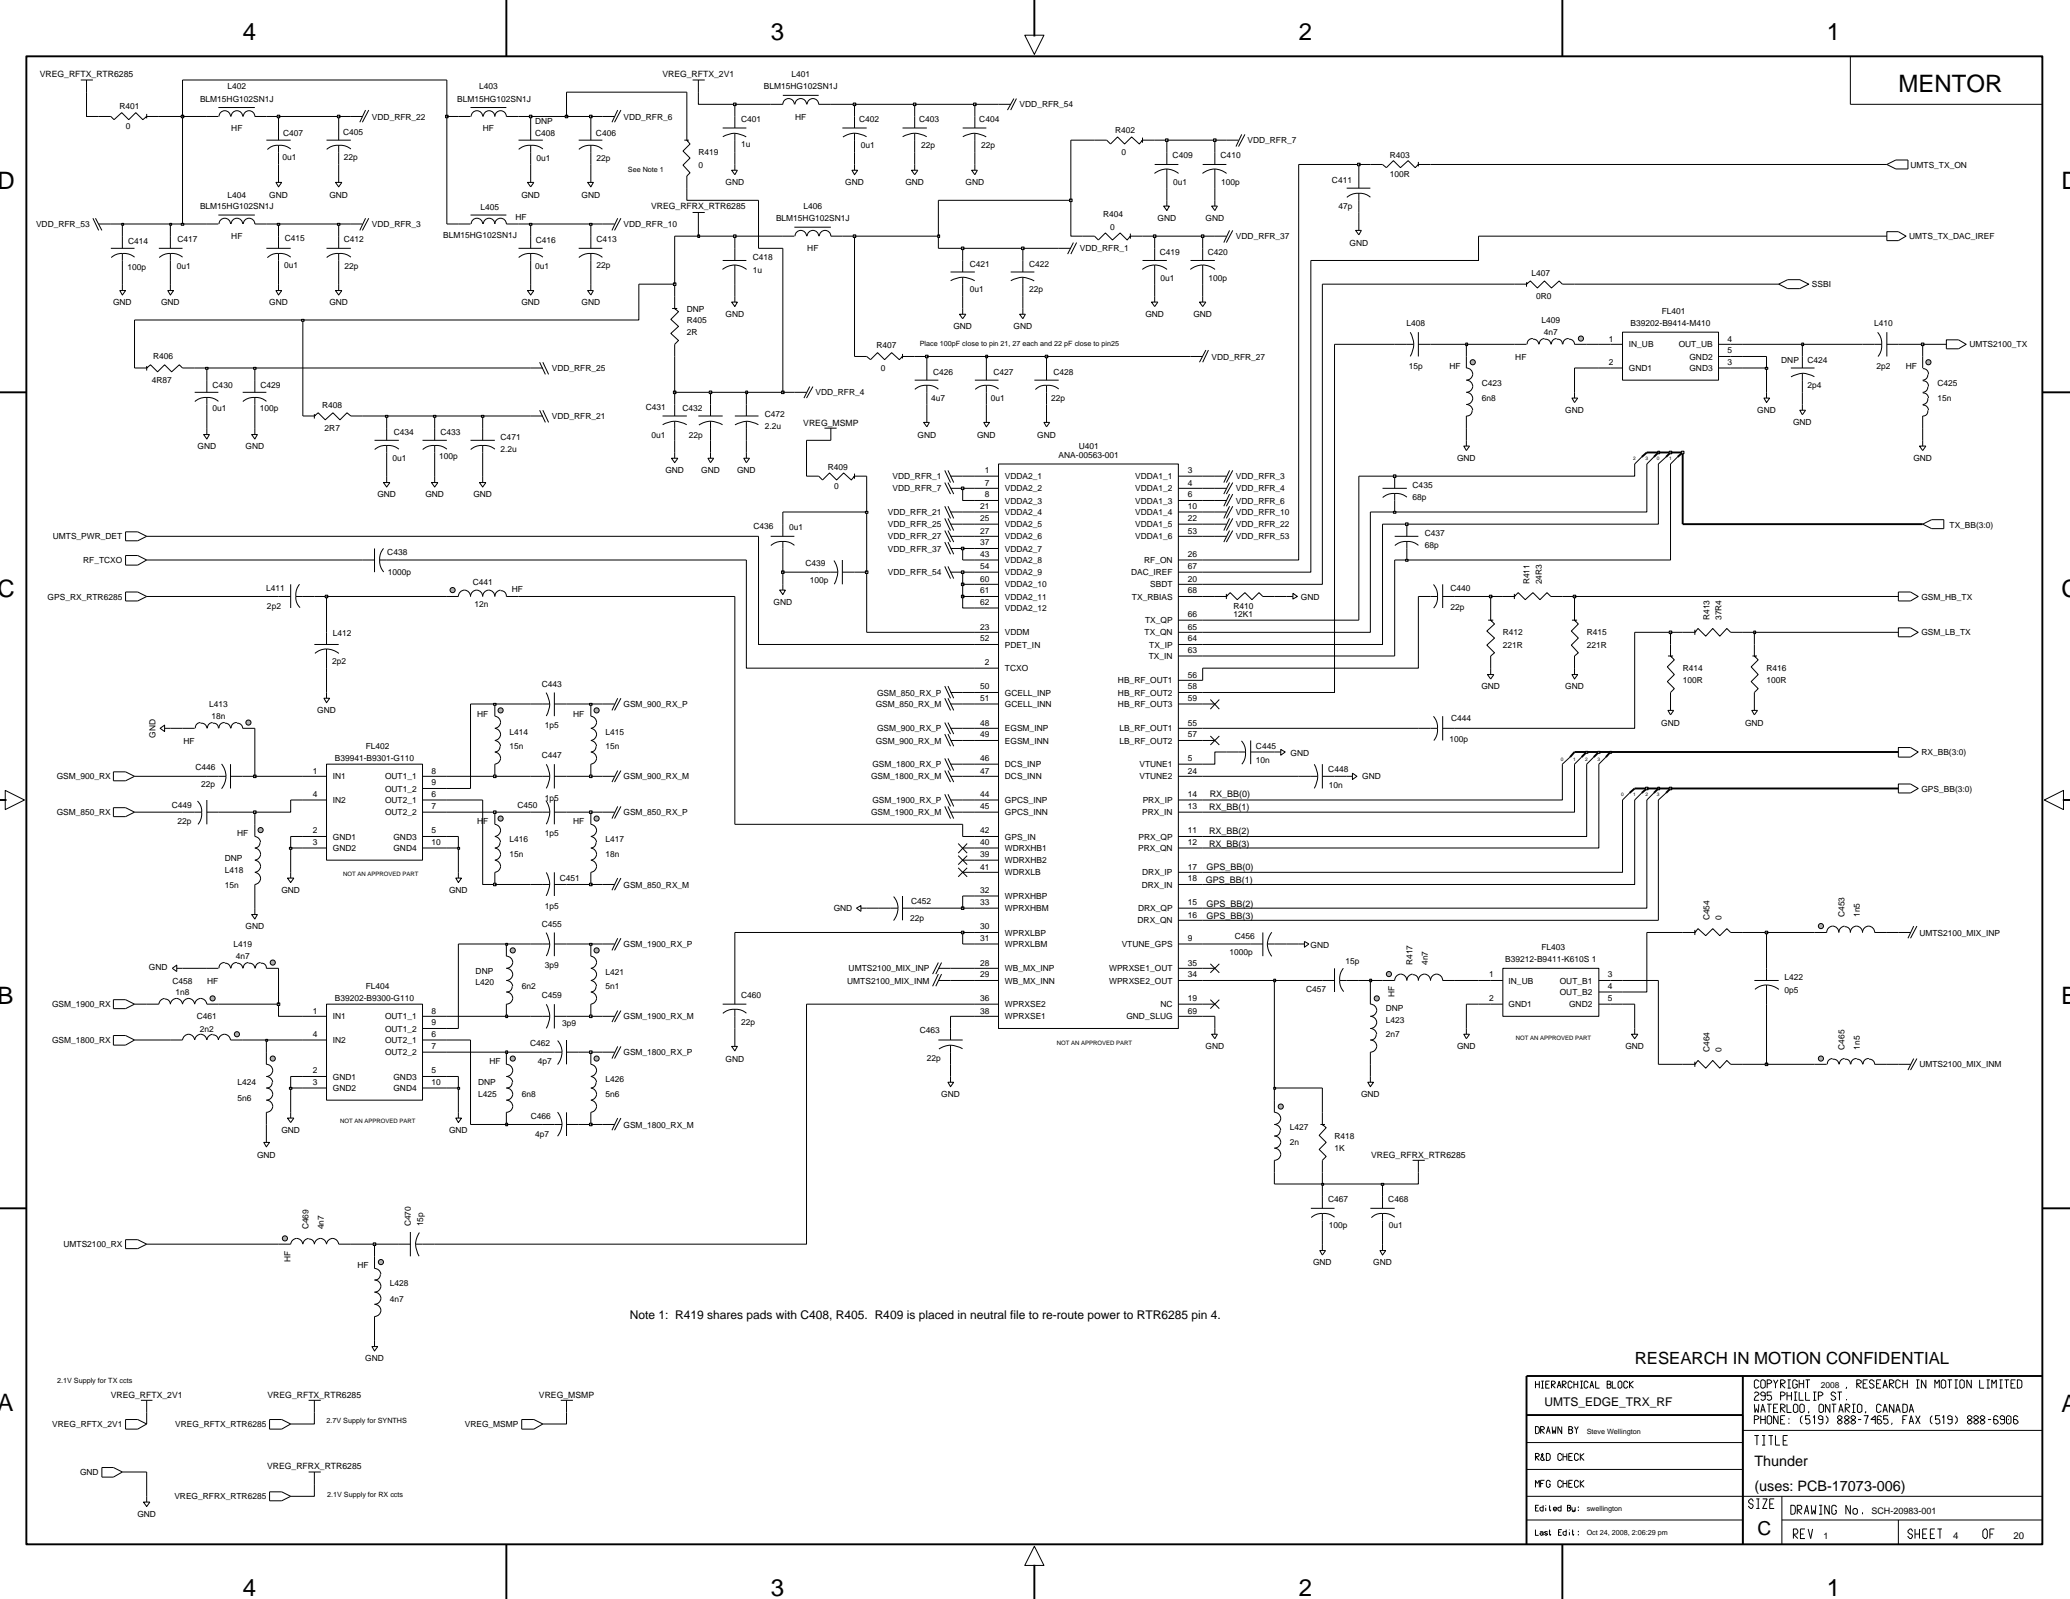




Note 1: R419 shares pads with C408, R405. R409 is placed in neutral file to re-route power to RTR6285 pin 4.

RESEARCH IN MOTION CONFIDENTIAL

HIERARCHICAL BLOCK UMTS_EDGE_TRX_RF		COPYRIGHT 2008, RESEARCH IN MOTION LIMITED 295 PHILLIP ST. WATERLOO, ONTARIO, CANADA PHONE: (519) 888-7465, FAX (519) 888-6306	
DRAWN BY Steve Wellington		TITLE Thunder	
R&D CHECK		(uses: PCB-17073-006)	
MFG CHECK		SIZE DRAWING No. SCH-20983-001	
Edi Led By: swellington		C REV 1 SHEET 4 OF 20	
Last Ed: Oct 24, 2008, 2:06:29 pm			

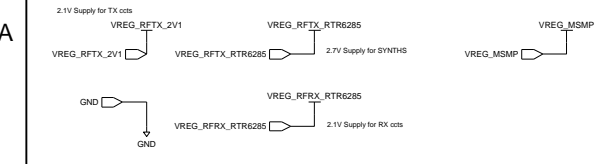


GPS ANTENNA CONNECTOR

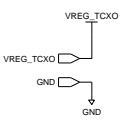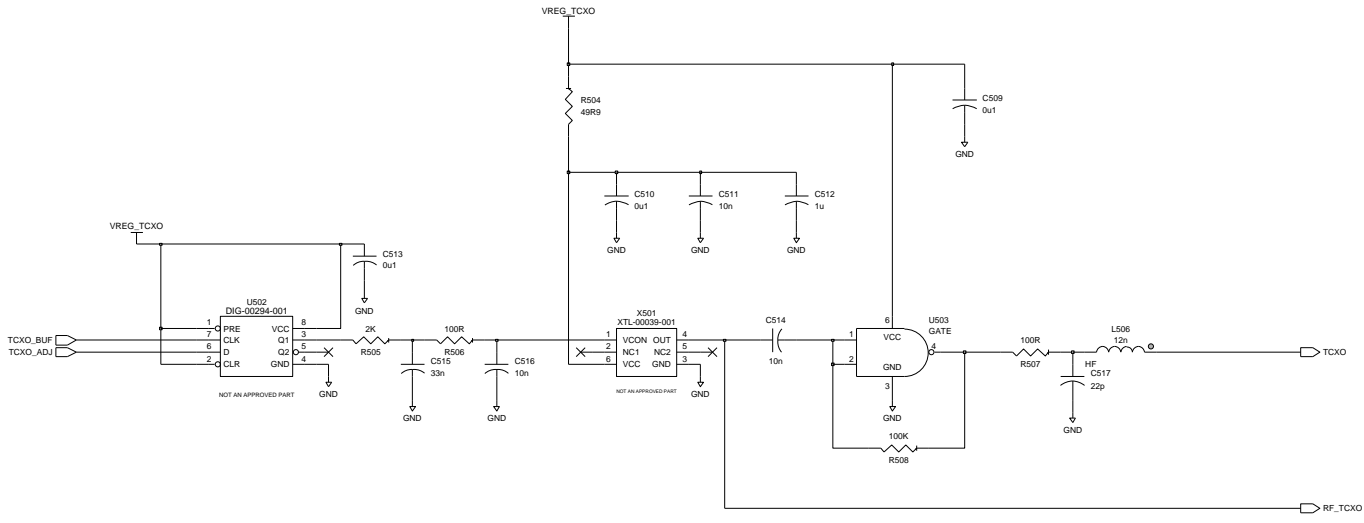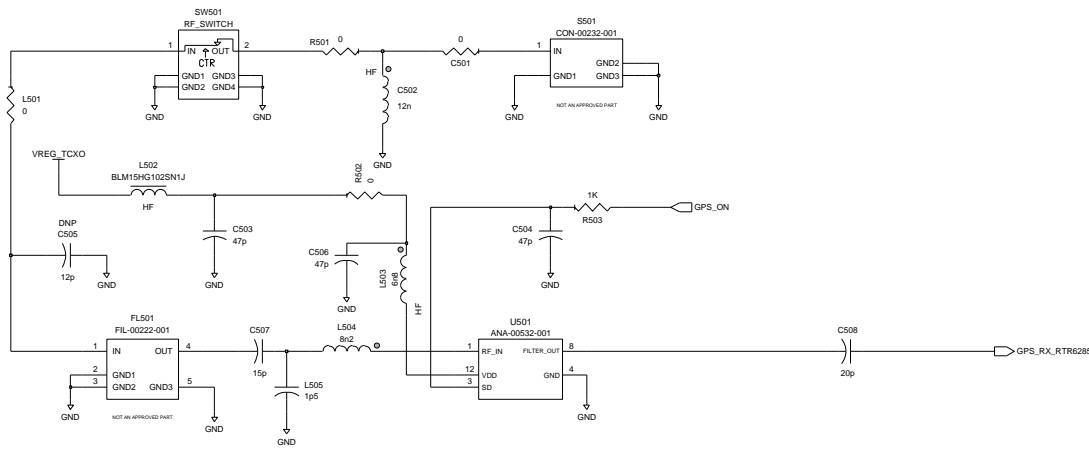

RESEARCH IN MOTION CONFIDENTIAL



HIERARCHICAL BLOCK GPS_SYNTH		COPYRIGHT 2008, RESEARCH IN MOTION LIMITED 295 PHILLIP ST. WATERLOO, ONTARIO, CANADA PHONE: (519) 888-7465, FAX (519) 888-6306	
DRAWN BY Steve Wellington		TITLE Thunder (uses: PCB-17073-006)	
R&D CHECK		SIZE DRAWING No. SCH-20983-001	
MFG CHECK		C REV 1 SHEET 5 OF 20	
Edi Led By: swellington			
Last Edt: Sep 29, 2008, 2:16:53 pm			

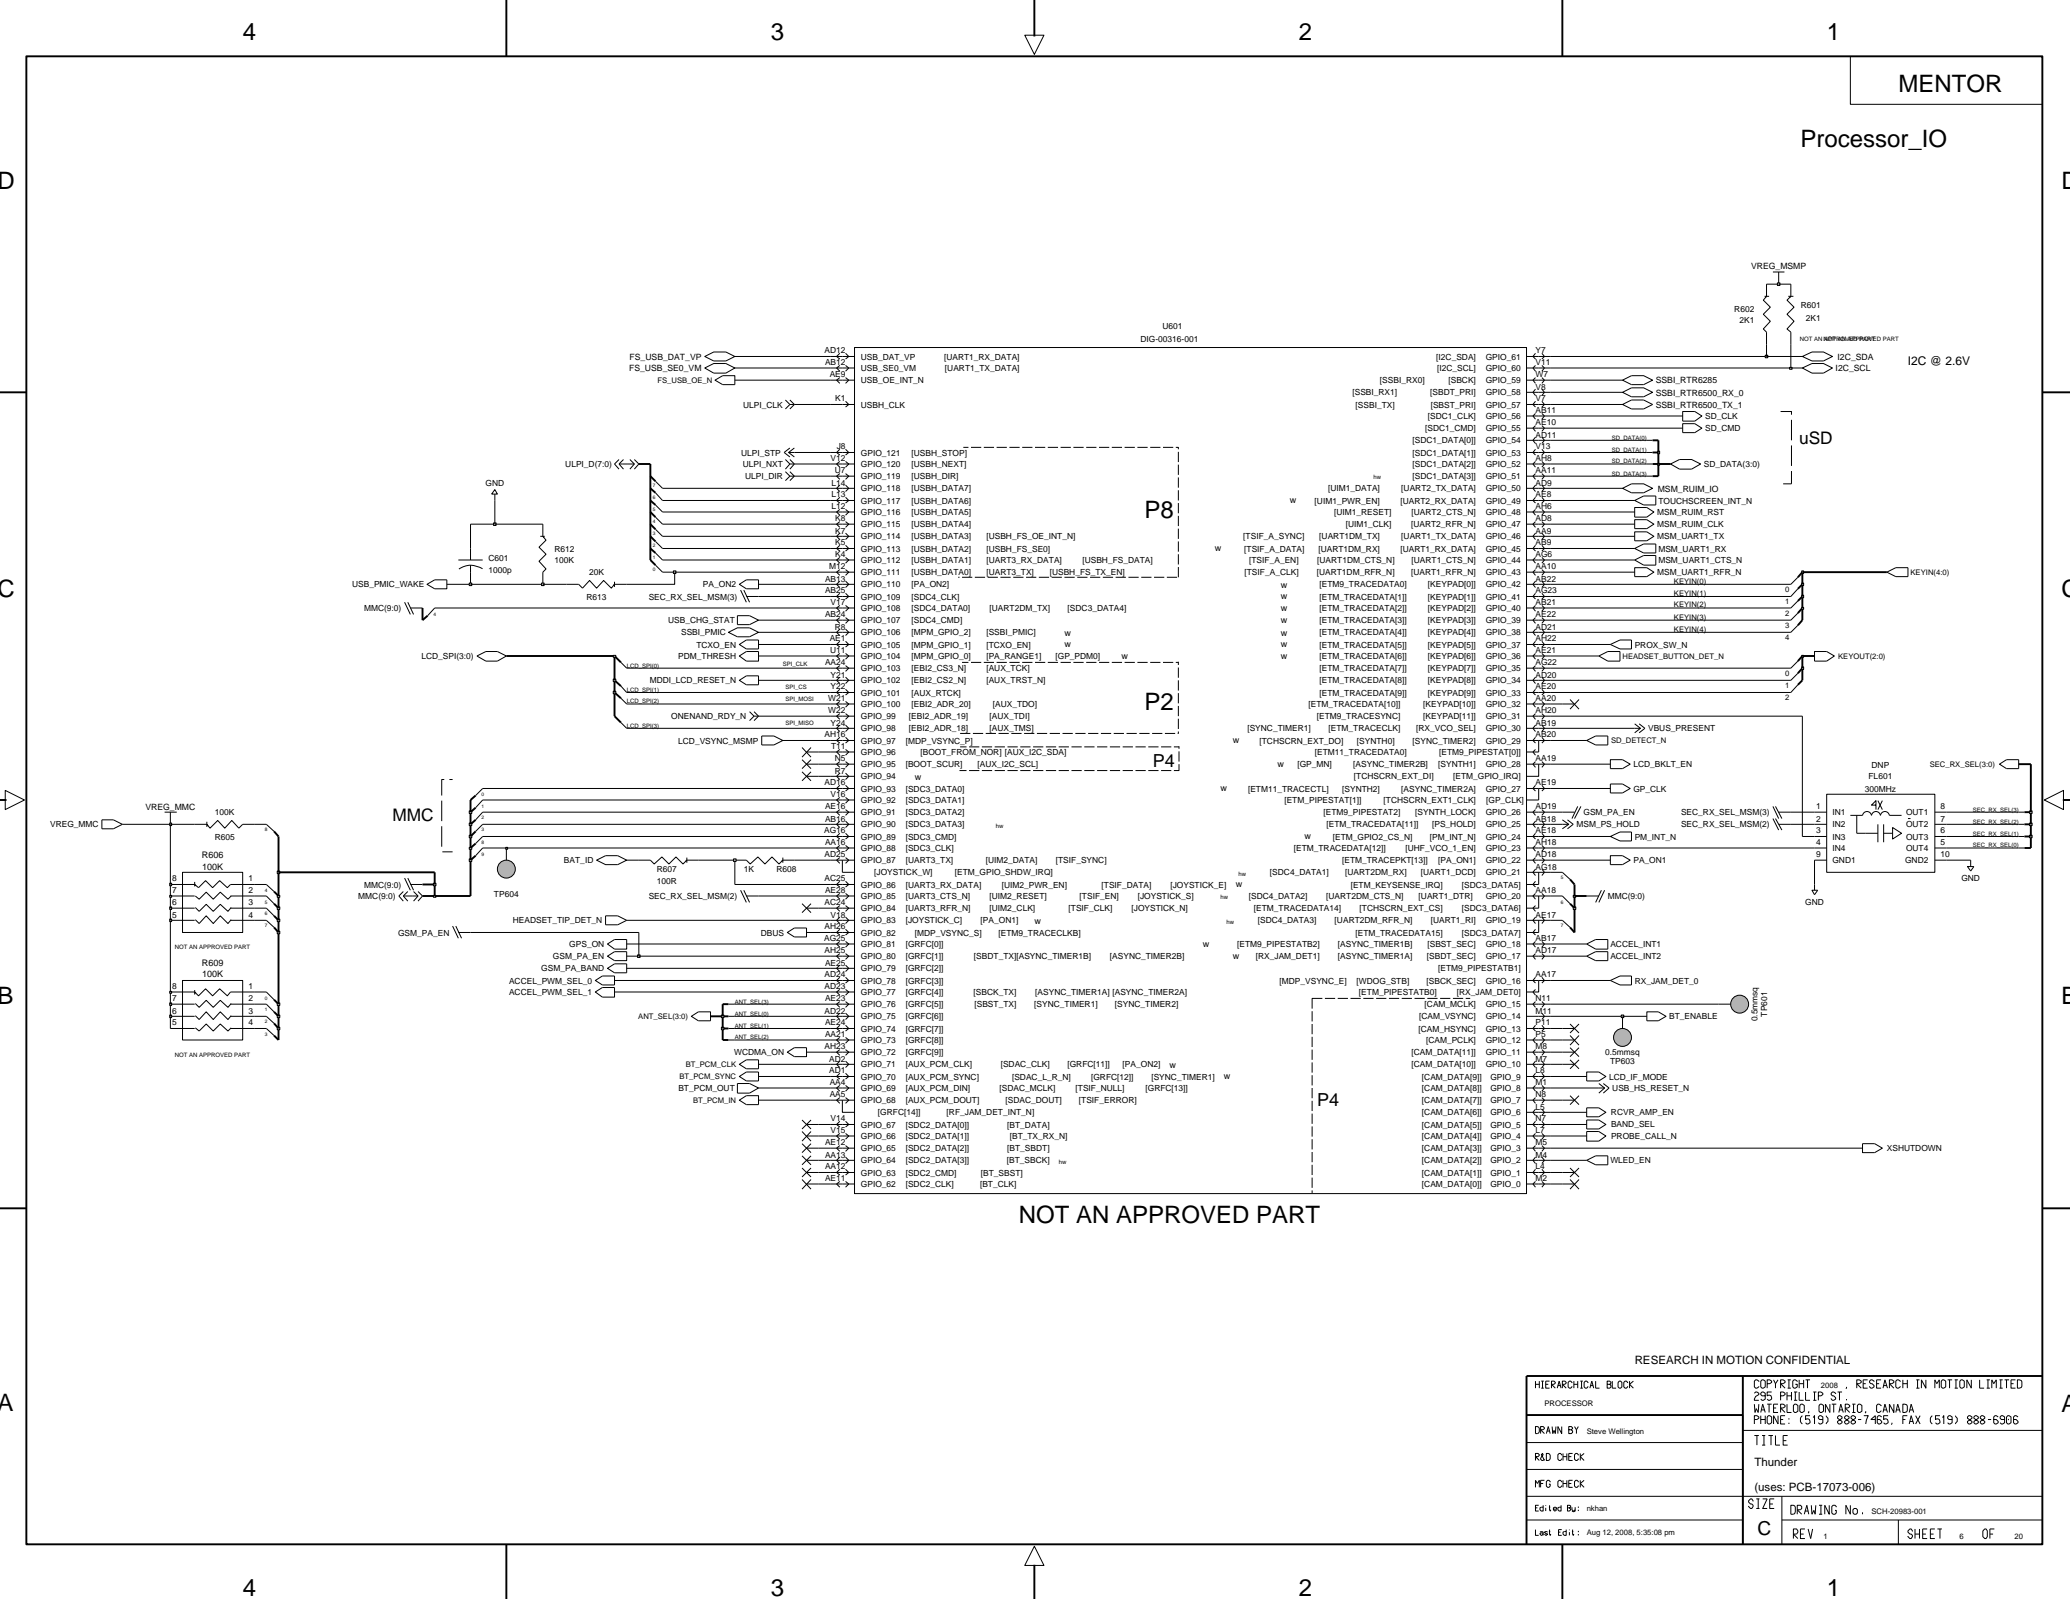


NOT AN APPROVED PART

RESEARCH IN MOTION CONFIDENTIAL


HIERARCHICAL BLOCK PROCESSOR		COPYRIGHT 2008, RESEARCH IN MOTION LIMITED 295 PHILLIP ST. WATERLOO, ONTARIO, CANADA PHONE: (519) 888-7465, FAX (519) 888-6306	
DRAWN BY Steve Wallington		TITLE Thunder	
R&D CHECK		(uses: PCB-17073-006)	
MFG CHECK		SIZE DRAWING No. SCH-20983-001	
Edi Led Bu: rkhani		C REV 1 SHEET 6 OF 20	
Last Edt: Aug 12, 2008, 5:36:08 pm			

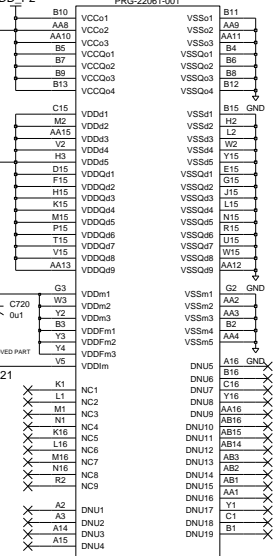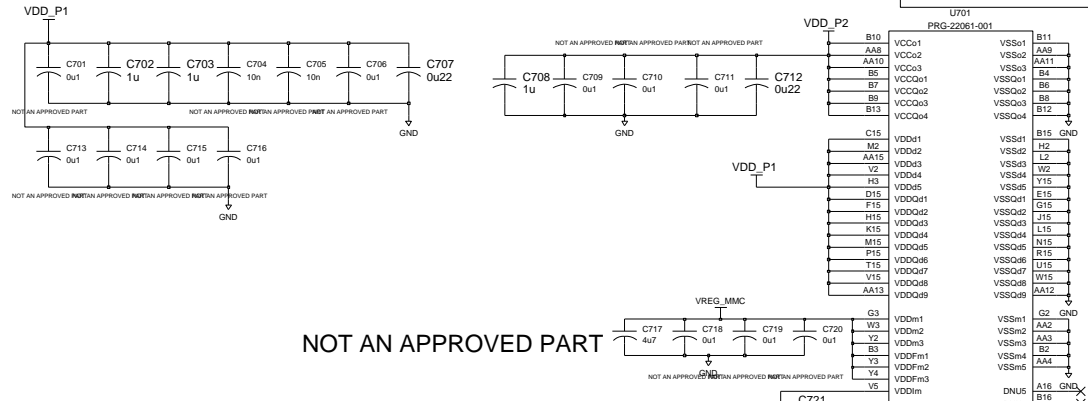

NOT AN APPROVED PART

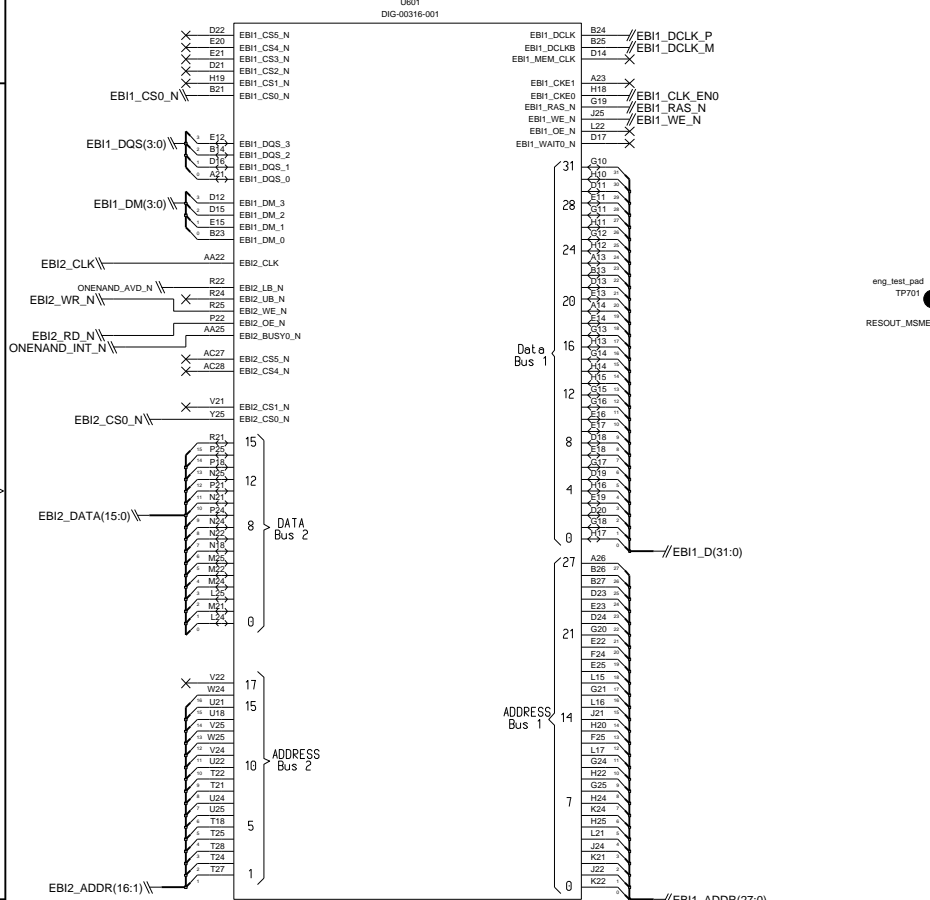


NOT AN APPROVED PART

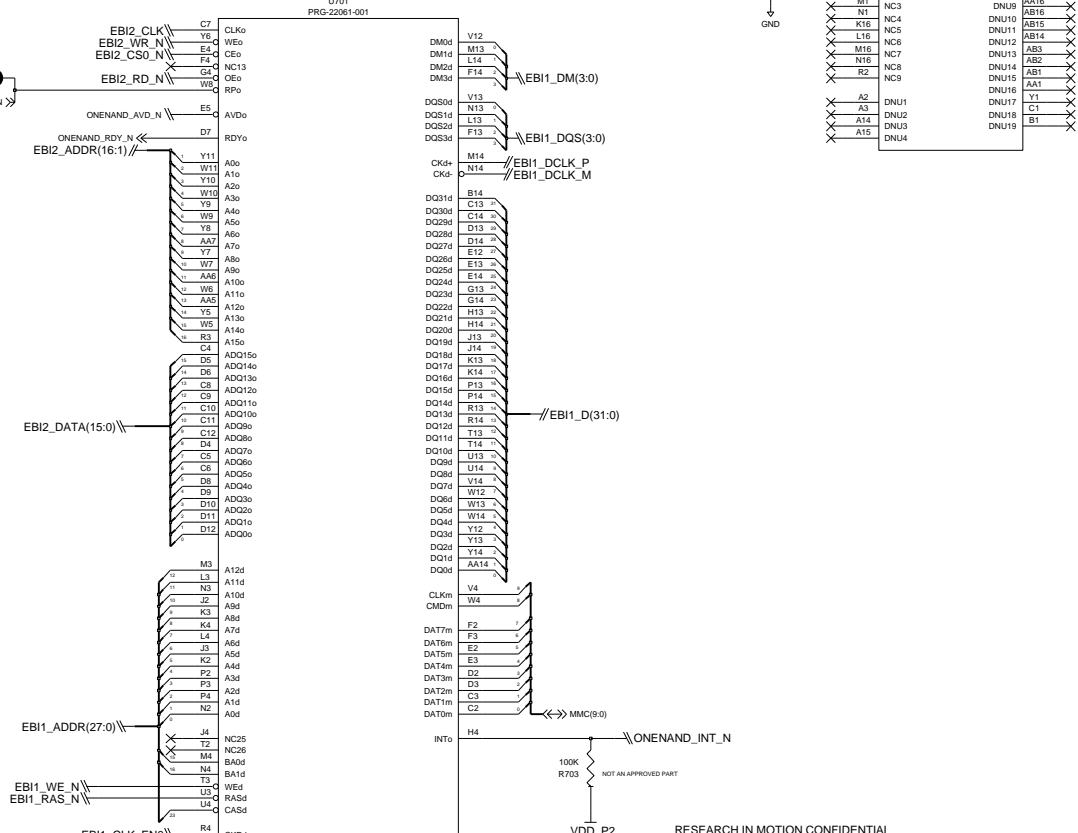

RESEARCH IN MOTION CONFIDENTIAL

HIERARCHICAL BLOCK PROCESSOR2	COPYRIGHT 2008 RESEARCH IN MOTION LIMITED 295 PHILLIP ST. WATERLOO, ONTARIO, CANADA PHONE: (519) 888-7465, FAX (519) 888-6306
DRAWN BY Steve Wellington	TITLE Thunder
R&D CHECK	(uses: PCB-17073-006)
FIG CHECK	SIZE DRAWING No. SCH-20983-001
Edi Led By: swellington	C REV 1 SHEET 7 OF 20
Last Ed1: Sep 24, 2008, 3:20:51 pm	

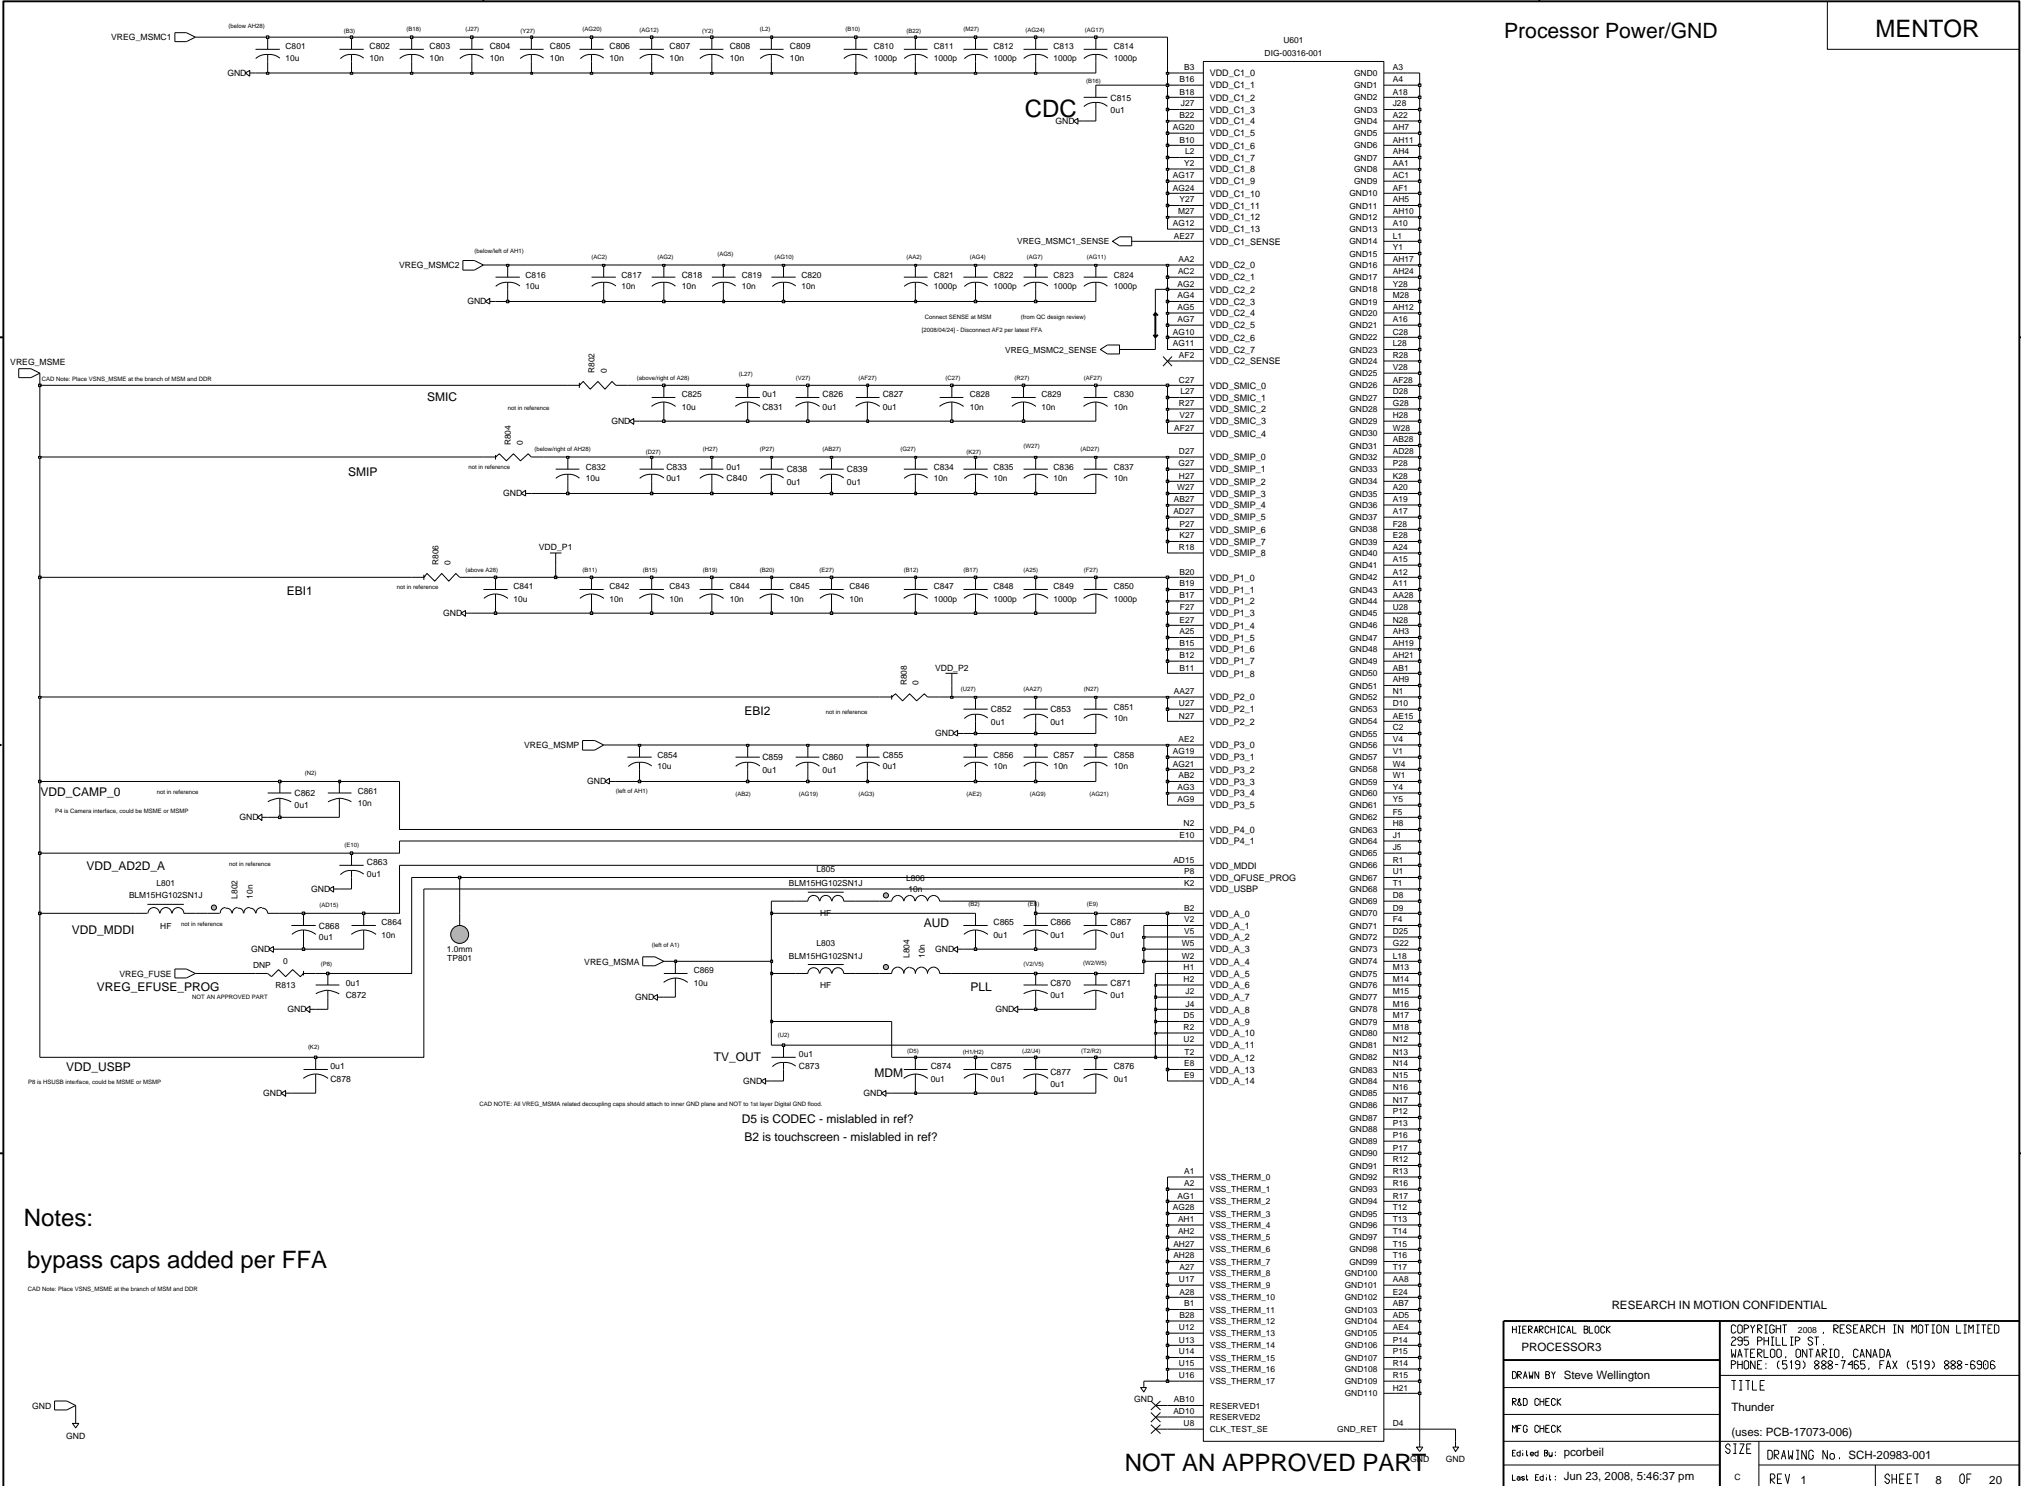

Notes:
bypass caps added per FFA


CAD Note: Place VSS_MSMC at the branch of MSM and DDR

D5 is CODEC - mislabeled in ref?
B2 is touchscreen - mislabeled in ref?

NOT AN APPROVED PART

RESEARCH IN MOTION CONFIDENTIAL


HIERARCHICAL BLOCK PROCESSOR3		COPYRIGHT 2008, RESEARCH IN MOTION LIMITED 295 PHILLIP ST. WATERLOO, ONTARIO, CANADA PHONE: (519) 888-7465, FAX (519) 888-6306	
DRAWN BY Steve Wellington		TITLE Thunder	
R&D CHECK		(uses: PCB-17073-006)	
MFG CHECK		SIZE DRAWING No. SCH-20983-001	
Edi Led By: pcorbell		c	
Last Edit: Jun 23, 2008, 5:46:37 pm		REV 1 SHEET 8 OF 20	

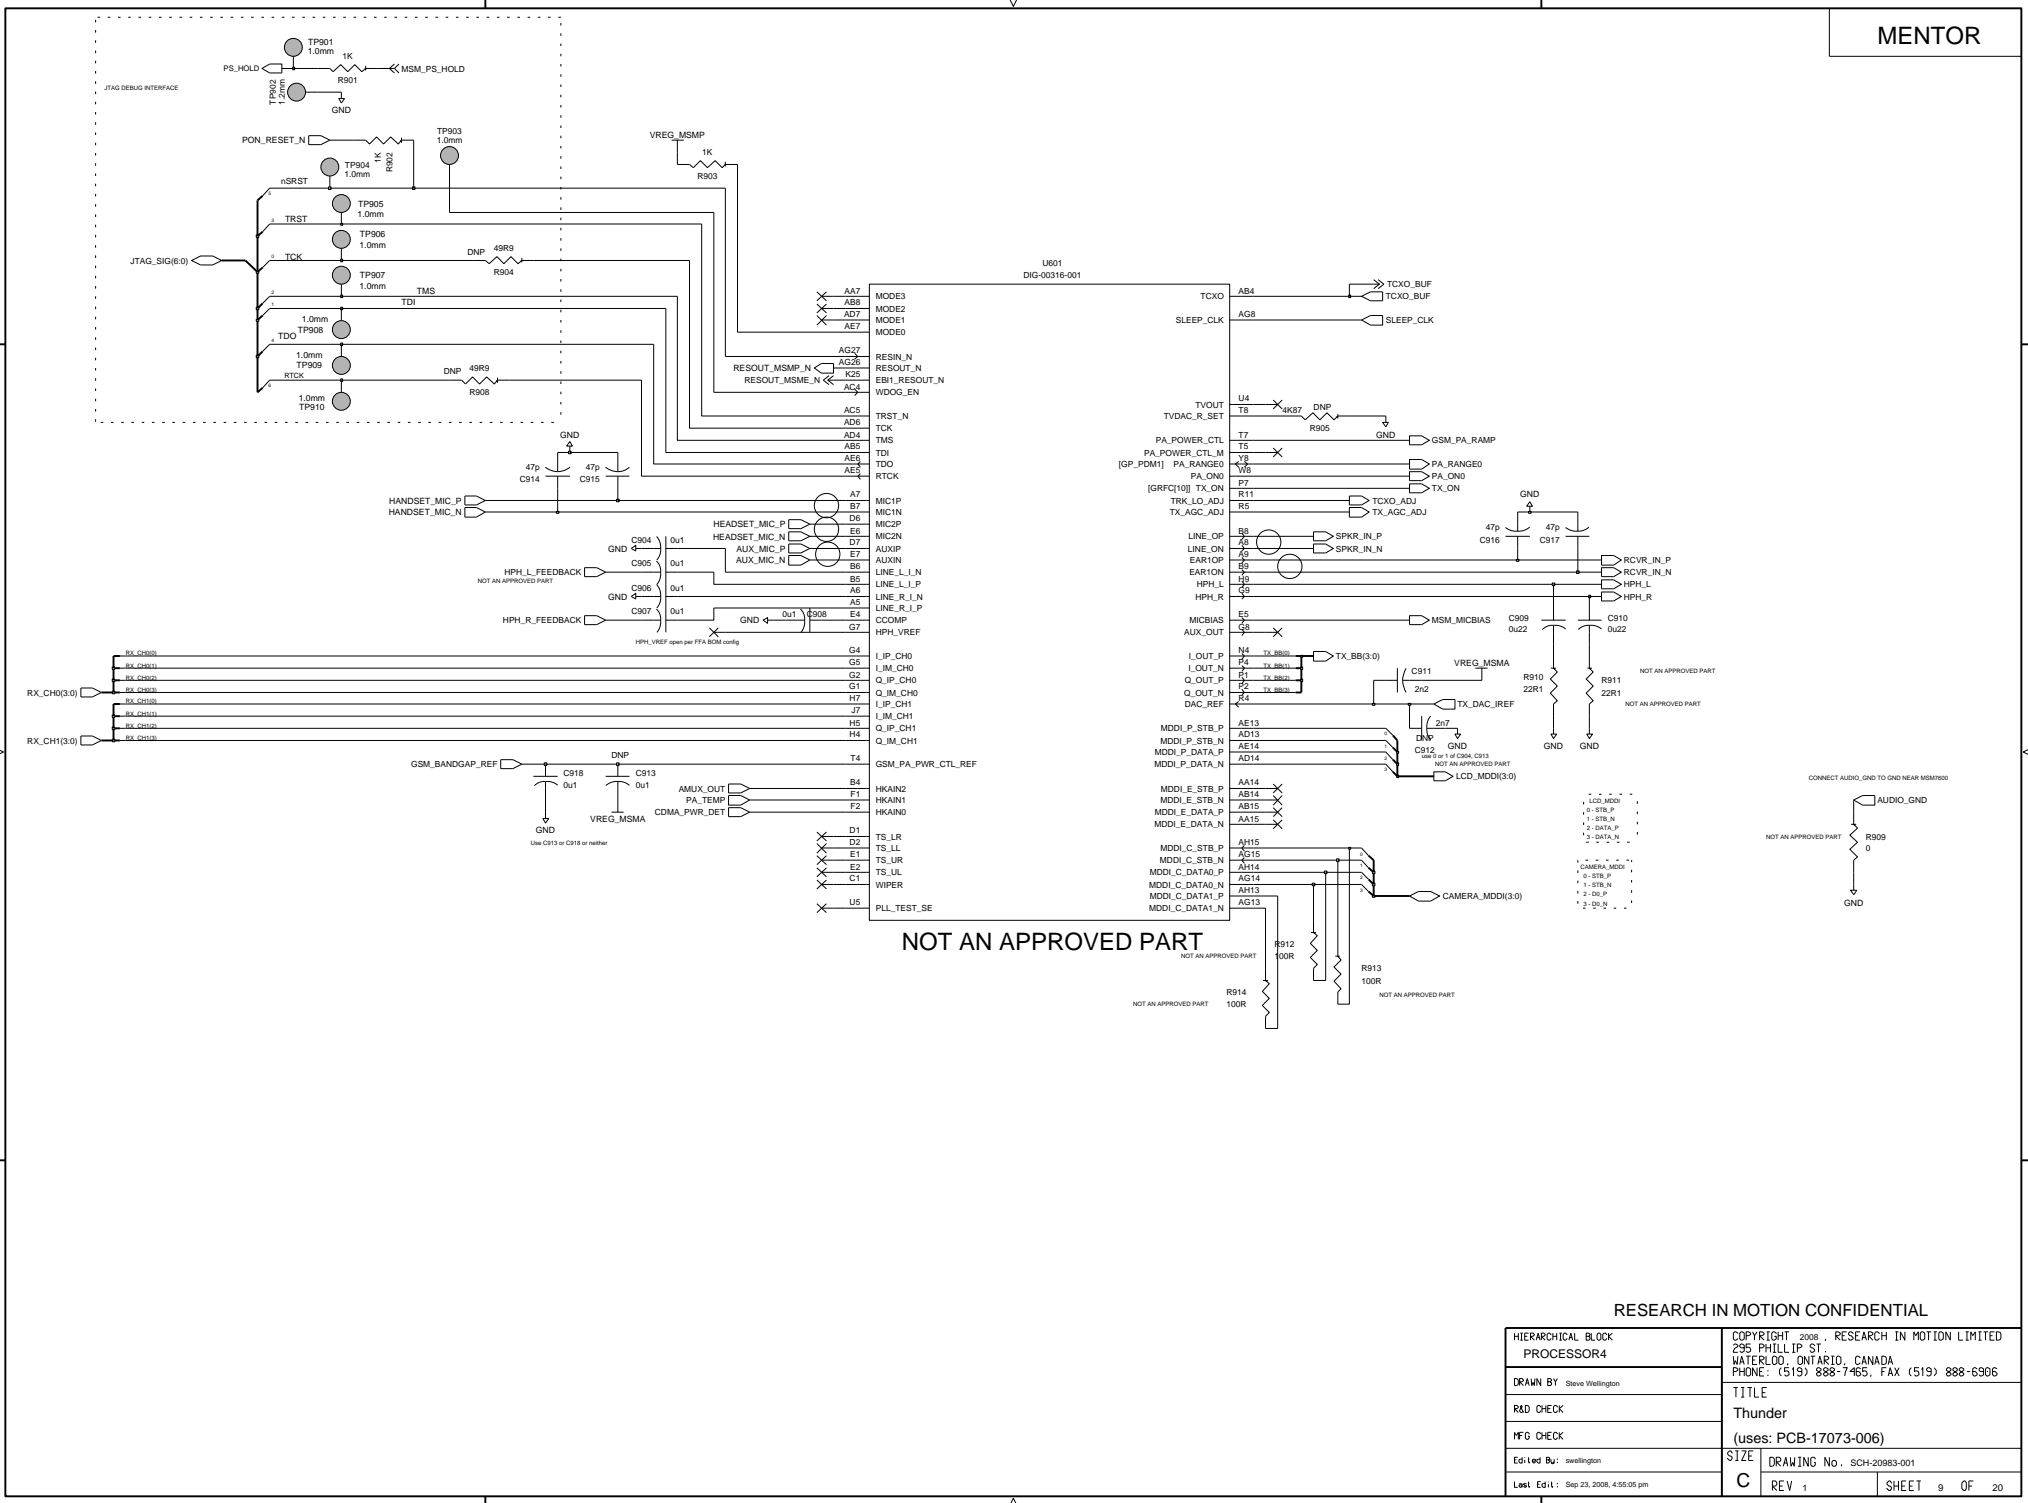

RESEARCH IN MOTION CONFIDENTIAL

HIERARCHICAL BLOCK PROCESSOR4		COPYRIGHT 2008, RESEARCH IN MOTION LIMITED 295 PHILLIP ST. WATERLOO, ONTARIO, CANADA PHONE: (519) 888-7465, FAX (519) 888-6306	
DRAWN BY Steve Wellington		TITLE Thunder	
R&D CHECK		(uses: PCB-17073-006)	
MFG CHECK		SIZE DRAWING No. SCH-20983-001	
Edi Led By: swellington		C REV 1 SHEET 9 OF 20	
Last Ed: Sep 23, 2008, 4:55:05 pm			




CHARGE/USB CONNECTOR

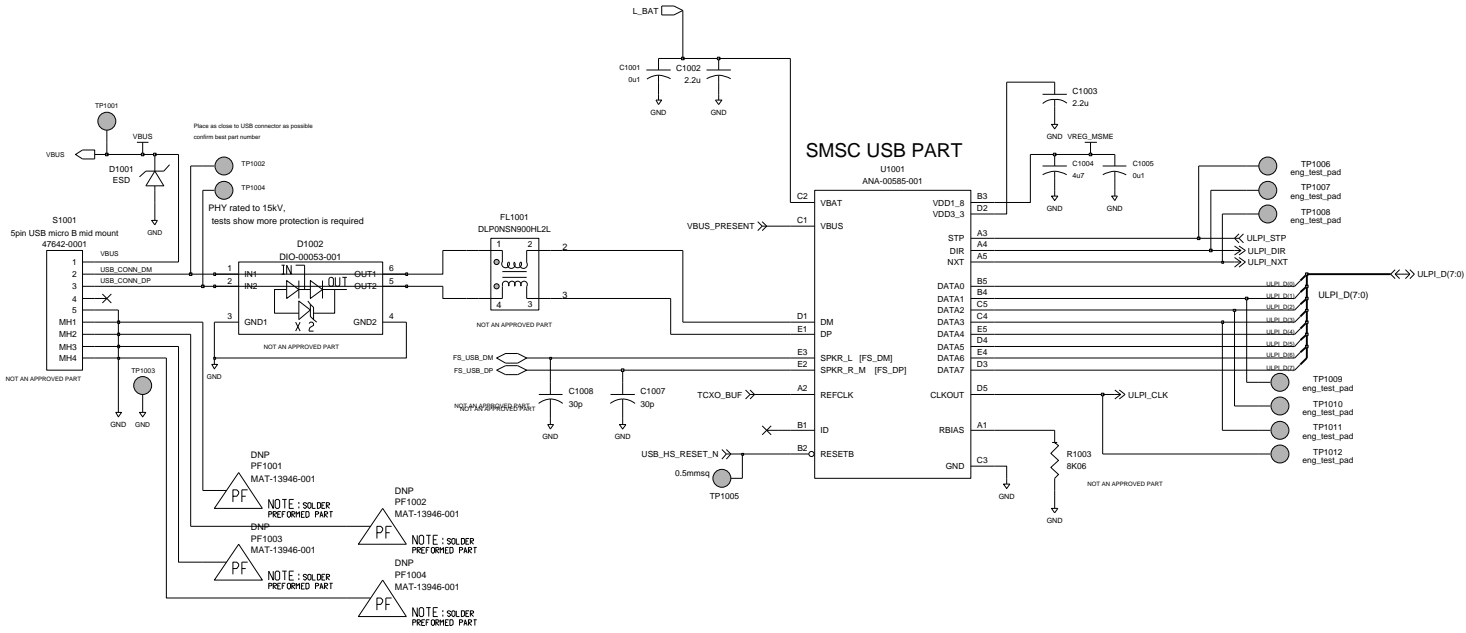

RESEARCH IN MOTION CONFIDENTIAL


HIERARCHICAL BLOCK PROCESSORS		COPYRIGHT 2008, RESEARCH IN MOTION LIMITED 295 PHILLIP ST. WATERLOO, ONTARIO, CANADA PHONE: (519) 888-7465, FAX (519) 888-6306	
DRAWN BY Steve Wellington		TITLE Thunder	
R&D CHECK		(uses: PCB-17073-006)	
MFG CHECK		DRAWING No. SCH-20983-001	
Ed: Led Bu: swellington		SIZE C	
Last Ed: 1 Oct 24, 2008, 2:12:26 pm		REV 1 SHEET 10 OF 20	

Route VREG_MSME as series from where trunk branches to processor and memory
recheck inductor current ratings based on MSM7600 loads

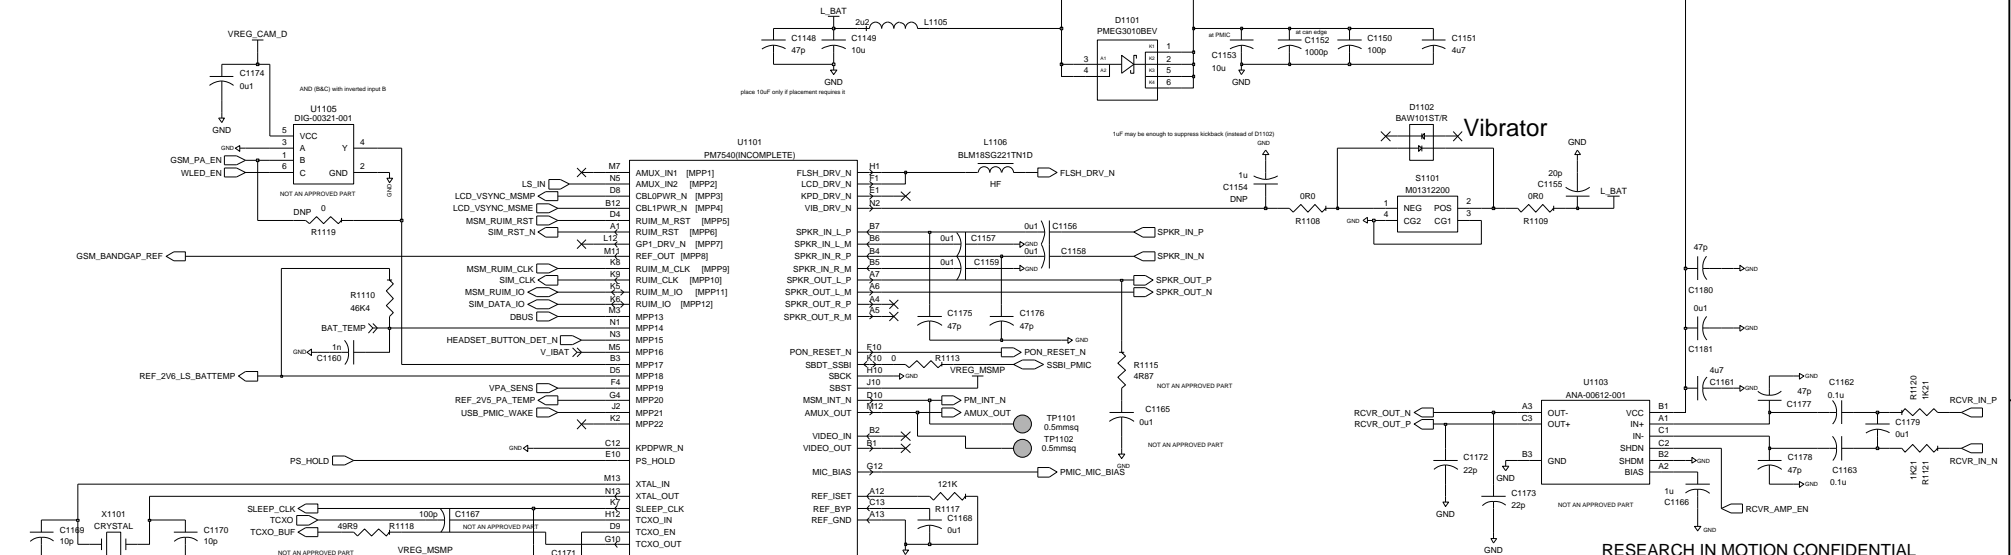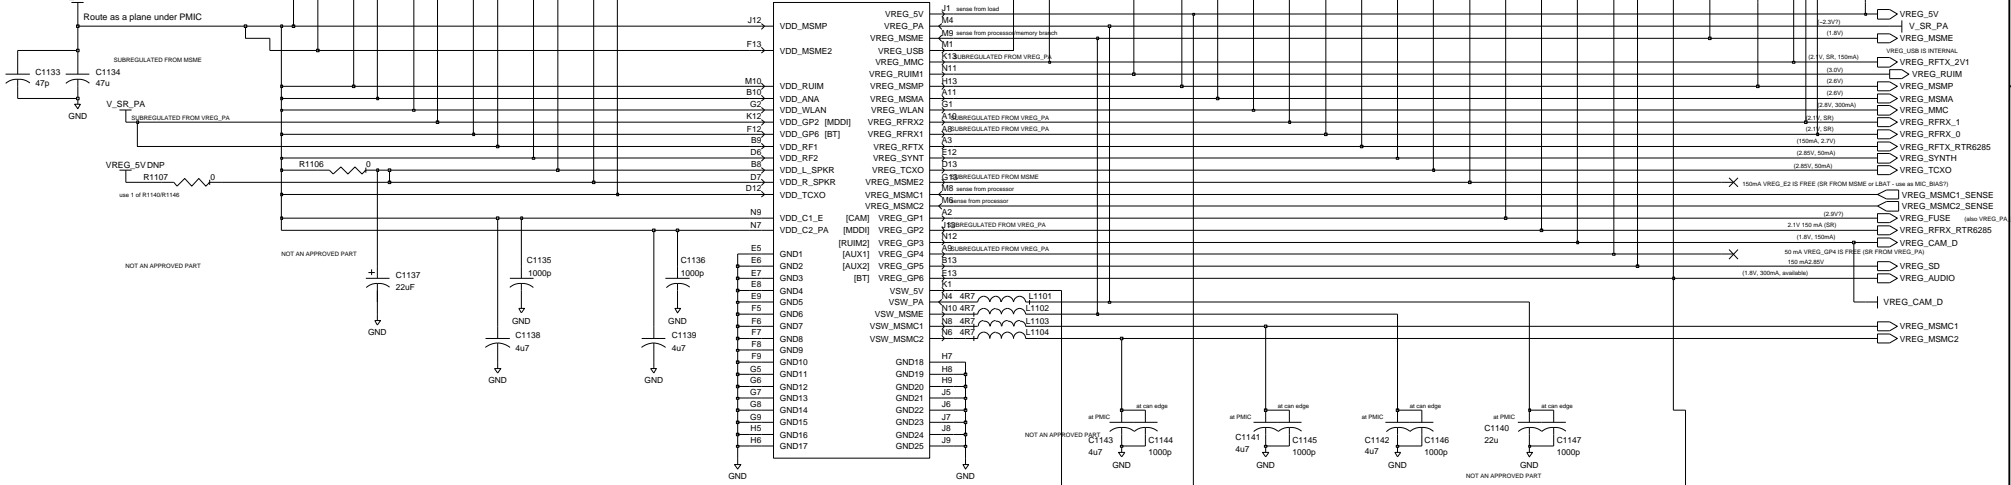
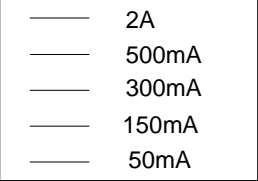


FC23 samples available in 12.5uF test cap
OK for PM7540 - could check



HIERARCHICAL BLOCK	POWER2
DRAWN BY	Steve Wellington
R&D CHECK	
IFG CHECK	
Edi Led Bu:	swellington
Level	Ed1: Sep 29, 2008, 1:07:20 pm
COPYRIGHT	© 2008, RESEARCH IN MOTION LIMITED
WATERLOO, ONTARIO, CANADA	PHONE: (519) 888-7465, FAX (519) 888-6306
TITLE	Thunder
(uses: PCB-17073-006)	
SIZE	DRAWING No. SCH-20983-001
REV 1	SHEET 11 OF 20

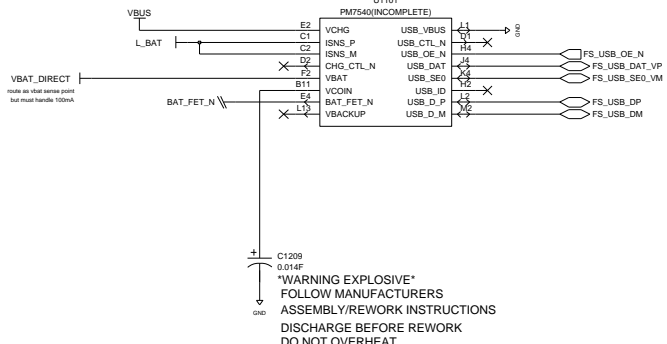

C1209
0.014F
WARNING EXPLOSIVE
FOLLOW MANUFACTURERS
ASSEMBLY/REWORK INSTRUCTIONS
DISCHARGE BEFORE REWORK
DO NOT OVERHEAT

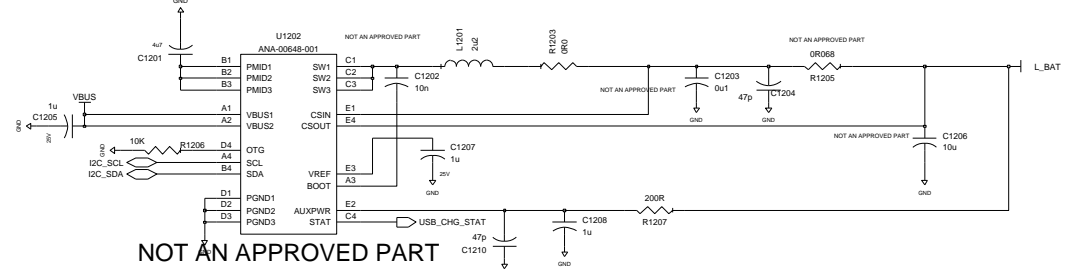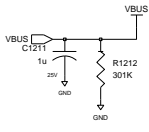


NOT AN APPROVED PART

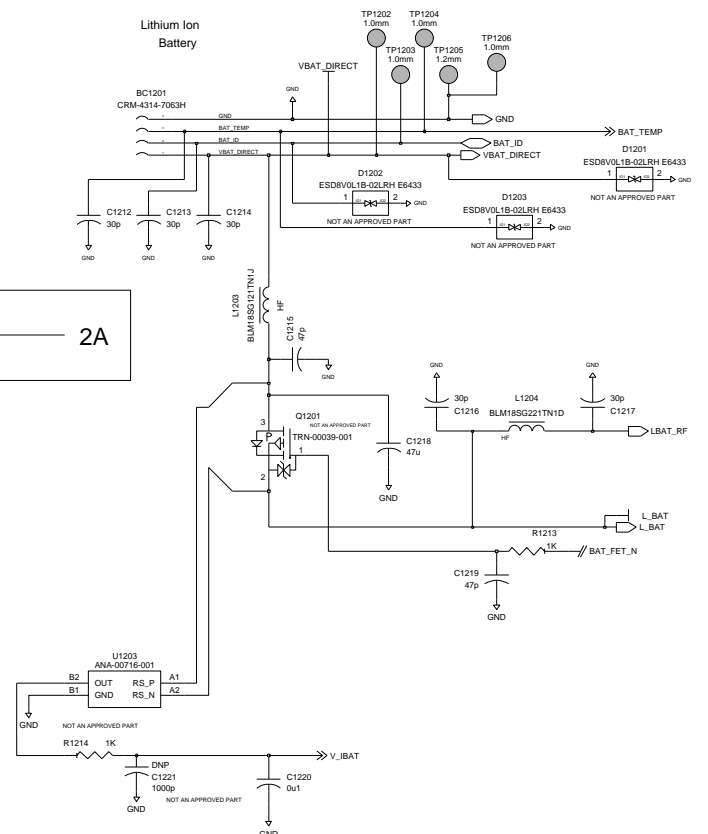 

RESEARCH IN MOTION CONFIDENTIAL



HIERARCHICAL BLOCK POWER22	COPYRIGHT 2008, RESEARCH IN MOTION LIMITED 295 PHILLIP ST. WATERLOO, ONTARIO, CANADA PHONE: (519) 888-7465, FAX (519) 888-6306
DRAWN BY Steve Wellington	TITLE Thunder
R&D CHECK	(uses: PCB-17073-006)
MFG CHECK	SIZE DRAWING No. SCH-20983-001
Edi Led By: swellington	C REV 1 SHEET 12 OF 20
Level Edi L: Oct 24, 2008, 2:00:10 pm	

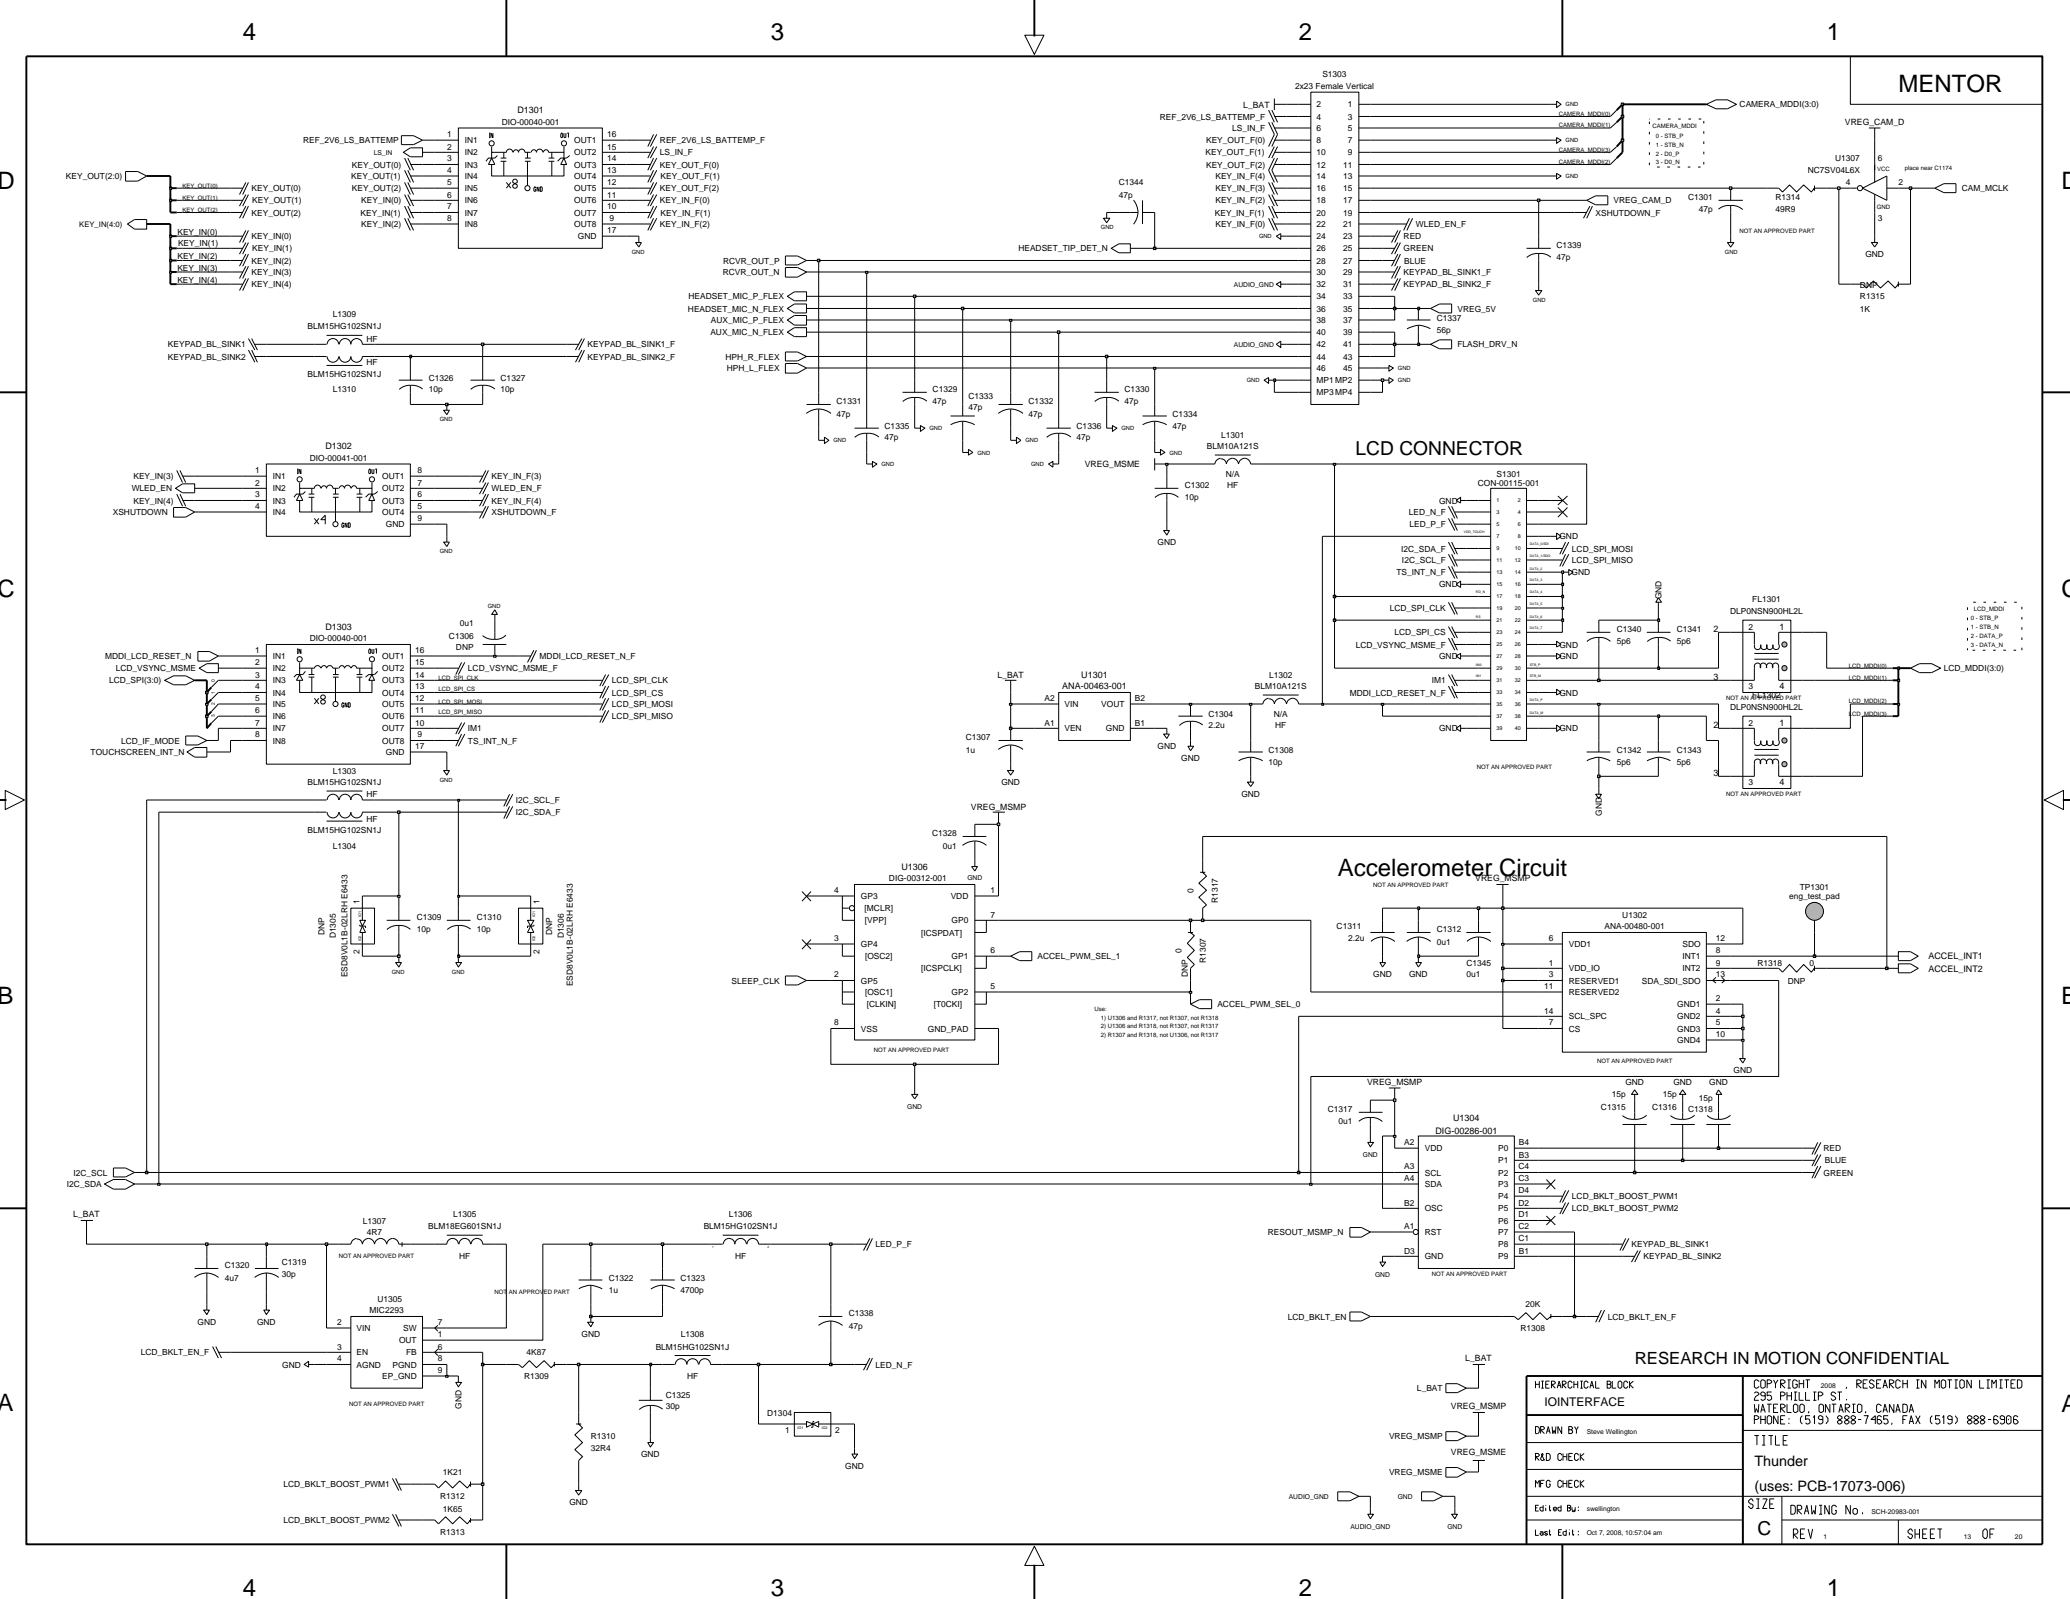


RESEARCH IN MOTION CONFIDENTIAL

HIERARCHICAL BLOCK	JOINTERFACE	COPYRIGHT 2008, RESEARCH IN MOTION LIMITED 295 PHILLIP ST. WATERLOO, ONTARIO, CANADA PHONE: (519) 888-7465, FAX (519) 888-6306
DRAWN BY	Steve Wellington	TITLE Thunder
R&D CHECK		(uses: PCB-17073-006)
HFG CHECK		SIZE DRAWING No. BCH-20983-001
Edi Led Bu: swillington		C REV 1 SHEET 13 OF 20
Label Ed1: Oct 7, 2008, 10:57:54 am		

BLUETOOTH ANTENNA

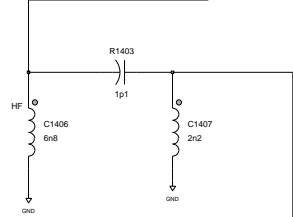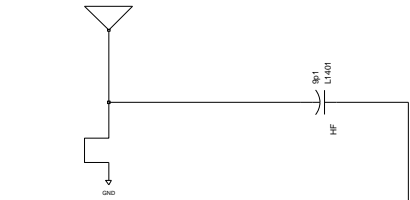

1 of L1407/R1421

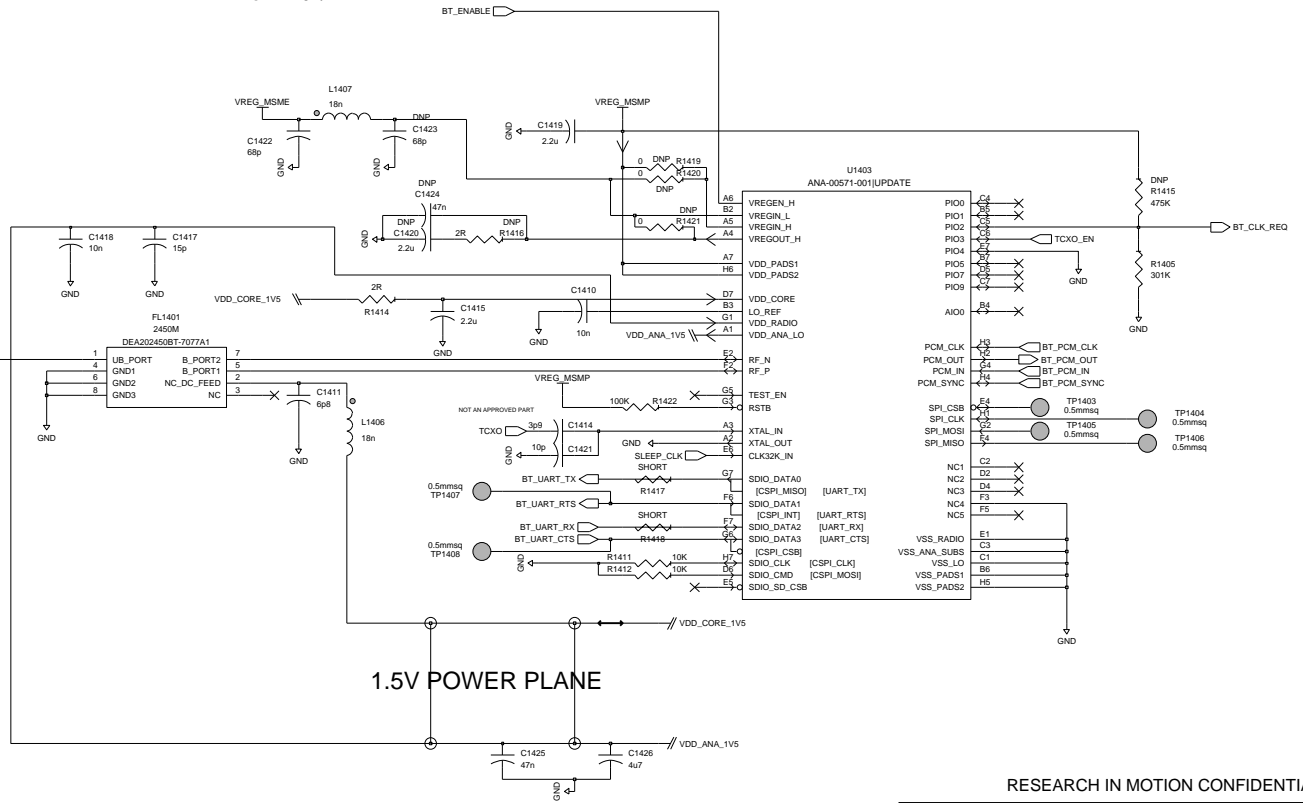

1.5V POWER PLANE

RESEARCH IN MOTION CONFIDENTIAL

HIERARCHICAL BLOCK BT_WLAN_XCVR		COPYRIGHT 2008, RESEARCH IN MOTION LIMITED 295 PHILLIP ST. WATERLOO, ONTARIO, CANADA PHONE: (519) 888-7465, FAX (519) 888-6306	
DRAWN BY: Steve Wellington		TITLE Thunder (uses: PCB-17073-006)	
R&D CHECK		SIZE DRAWING No. SCH-20983-001	
MFG CHECK		REV 1 SHEET 14 OF 20	
Edi Led By: swellington		Last Ed1: Sep 29, 2008, 2:14:53 pm	

4

3

2

1

MENTOR

D

D

C

C

B

B

A

A

RESEARCH IN MOTION CONFIDENTIAL


HIERARCHICAL BLOCK CDMA_TRX_RF2		COPYRIGHT 2007, RESEARCH IN MOTION LIMITED 295 PHILLIP ST. WATERLOO, ONTARIO, CANADA PHONE: (519) 888-7465, FAX (519) 888-6306	
DRAWN BY: Steve Wellington		TITLE Thunder (uses: PCB-17073-006)	
R&D CHECK		SIZE	
MFG CHECK		C	
Ed: Led By: swellington		DRAWING No. SCH-20983-001	
Last Ed: 11 Nov 25, 2007, 2:07:14 am		REV 1	SHEET 15 OF 20

4


3

2


1

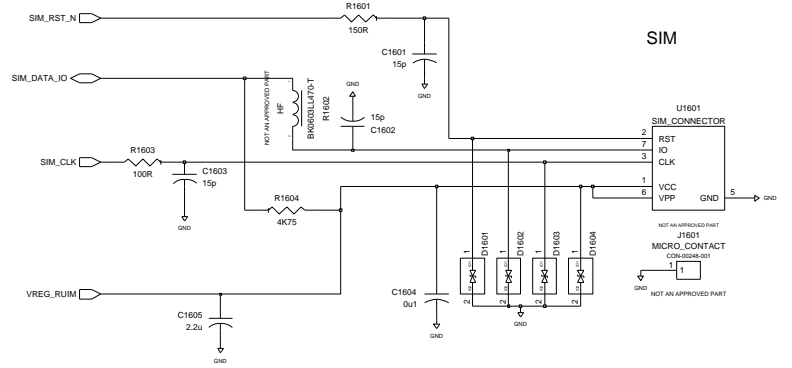

GPS COAX CLIP

 

 
2.05_SINGLE_OFFSET_REDUCED





2.05_SINGLE_OFFSET_REDUCED



 2.05_SINGLE_OFFSET_REDUCED










2.05_SINGLE_OFFSET_REDUCED

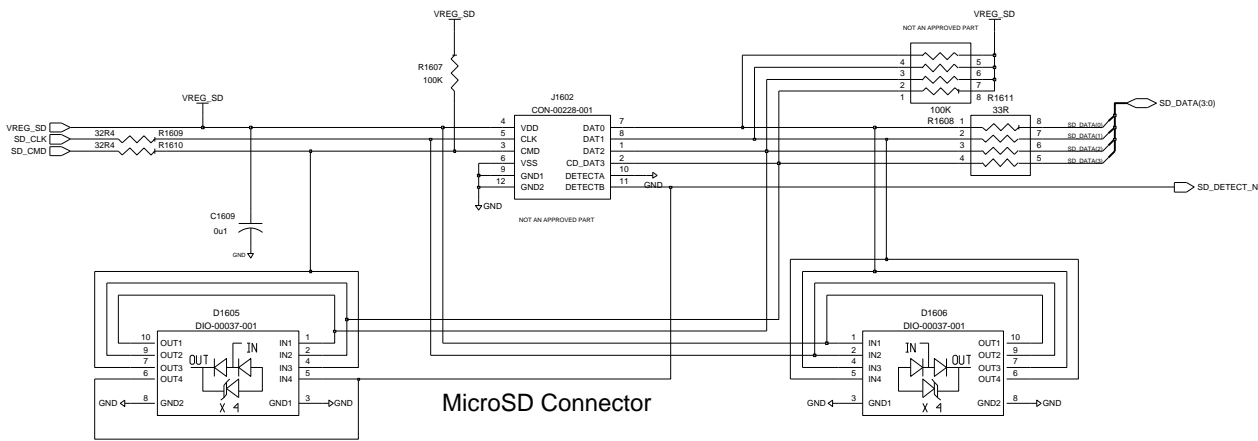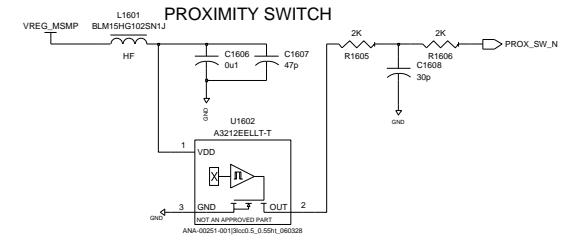

RESEARCH IN MOTION CONFIDENTIAL

HIERARCHICAL BLOCK KEYBRD		COPYRIGHT 2008, RESEARCH IN MOTION LIMITED 295 PHILLIP ST. WATERLOO, ONTARIO, CANADA PHONE: (519) 888-7465, FAX (519) 888-6306	
DRAWN BY Steve Wellington		TITLE Thunder	
R&D CHECK		(uses: PCB-17073-006)	
MFG CHECK		SIZE DRAWING No. SCH-20983-001	
Edi Led Bu: swellington		C REV 1 SHEET 16 OF 20	
Last Ed1: Sep 29, 2008, 1:03:04 pm			

HANDSET MIC

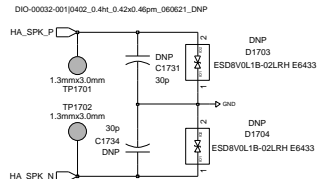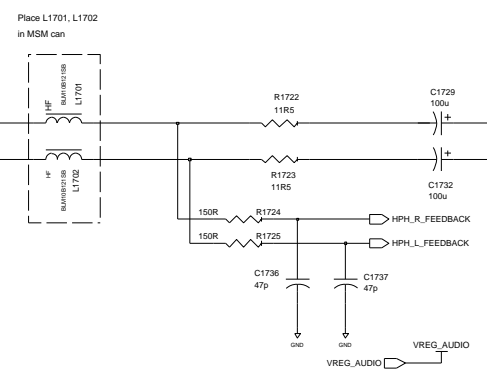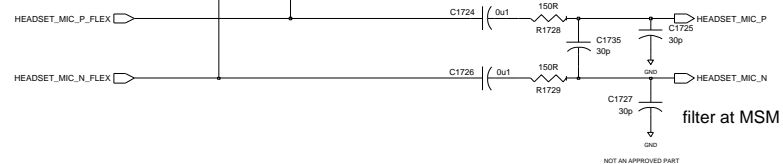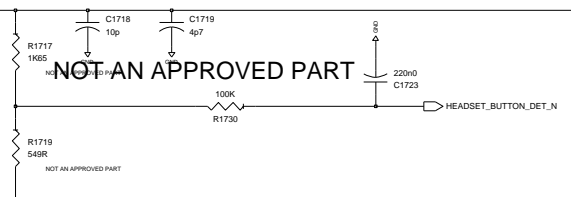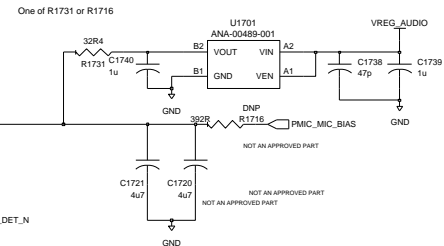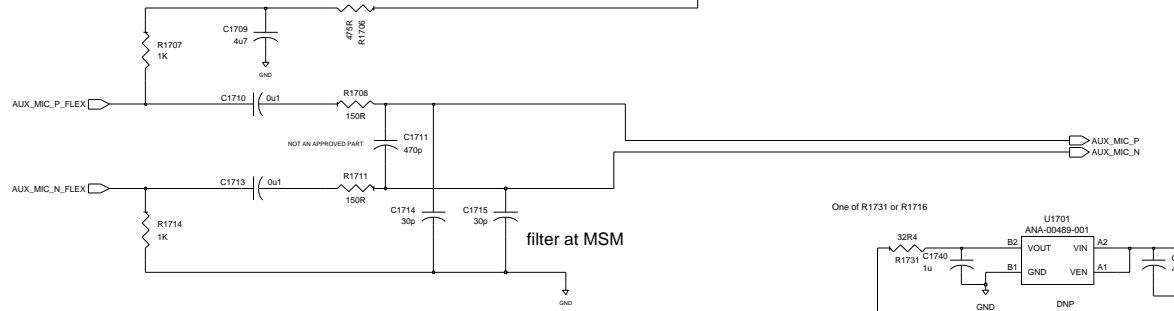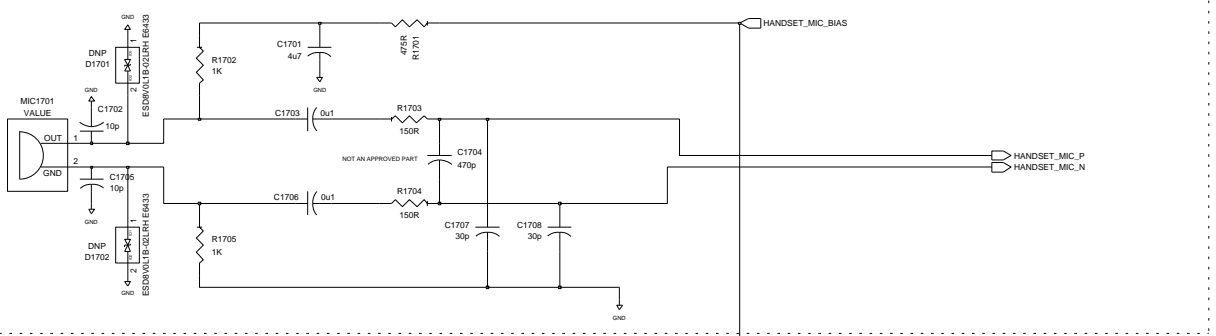

RESEARCH IN MOTION CONFIDENTIAL













HIERARCHICAL BLOCK AUDIO		COPYRIGHT 2008, RESEARCH IN MOTION LIMITED 295 PHILLIP ST. WATERLOO, ONTARIO, CANADA PHONE: (519) 888-7465, FAX (519) 888-6306	
DRAWN BY: Steve Wellington		TITLE Thunder (uses: PCB-17073-006)	
R&D CHECK		SIZE DRAWING No. SCH-20983-001	
MFG CHECK		REV 1 SHEET 17 OF 20	
Edi Led Bu: swellington		Last Edt: Sep 29, 2008, 1:00:01 pm	

4

3

2

            1



RESEARCH IN MOTION CONFIDENTIAL

HIERARCHICAL BLOCK JOINTERFACE2		COPYRIGHT 2008 . RESEARCH IN MOTION LIMITED 295 PHILLIP ST. WATERLOO, ONTARIO, CANADA PHONE: (519) 888-7465, FAX (519) 888-6306	
DRAWN BY: Steve Wellington		TITLE Thunder	
R&D CHECK		(uses: PCB-17073-006)	
MFG CHECK		SIZE	
Edi Led By: swellington		DRAWING No. SCH-20983-001	
Last Edt: Sep 29, 2008, 12:57:16 pm		C	REV 1 SHEET 18 OF 20

4

3

2

1

D

C

B

A

4

3

2

1

MENTOR

D

D

C

C

B

B

A

A

RESEARCH IN MOTION CONFIDENTIAL


HIERARCHICAL BLOCK BT_XCVR2		COPYRIGHT 2007, RESEARCH IN MOTION LIMITED 295 PHILLIP ST. WATERLOO, ONTARIO, CANADA PHONE: (519) 888-7465, FAX (519) 888-6306	
DRAWN BY: Steve Wellington		TITLE Thunder (uses: PCB-17073-006)	
R&D CHECK		SIZE	
MFG CHECK		DRAWING No. SCH-209893-001	
Ed: Led By: swellington		C	
Last Ed: 1: Oct 29, 2007, 11:40:20 am		REV 1 SHEET 19 OF 20	

4

3

2

1

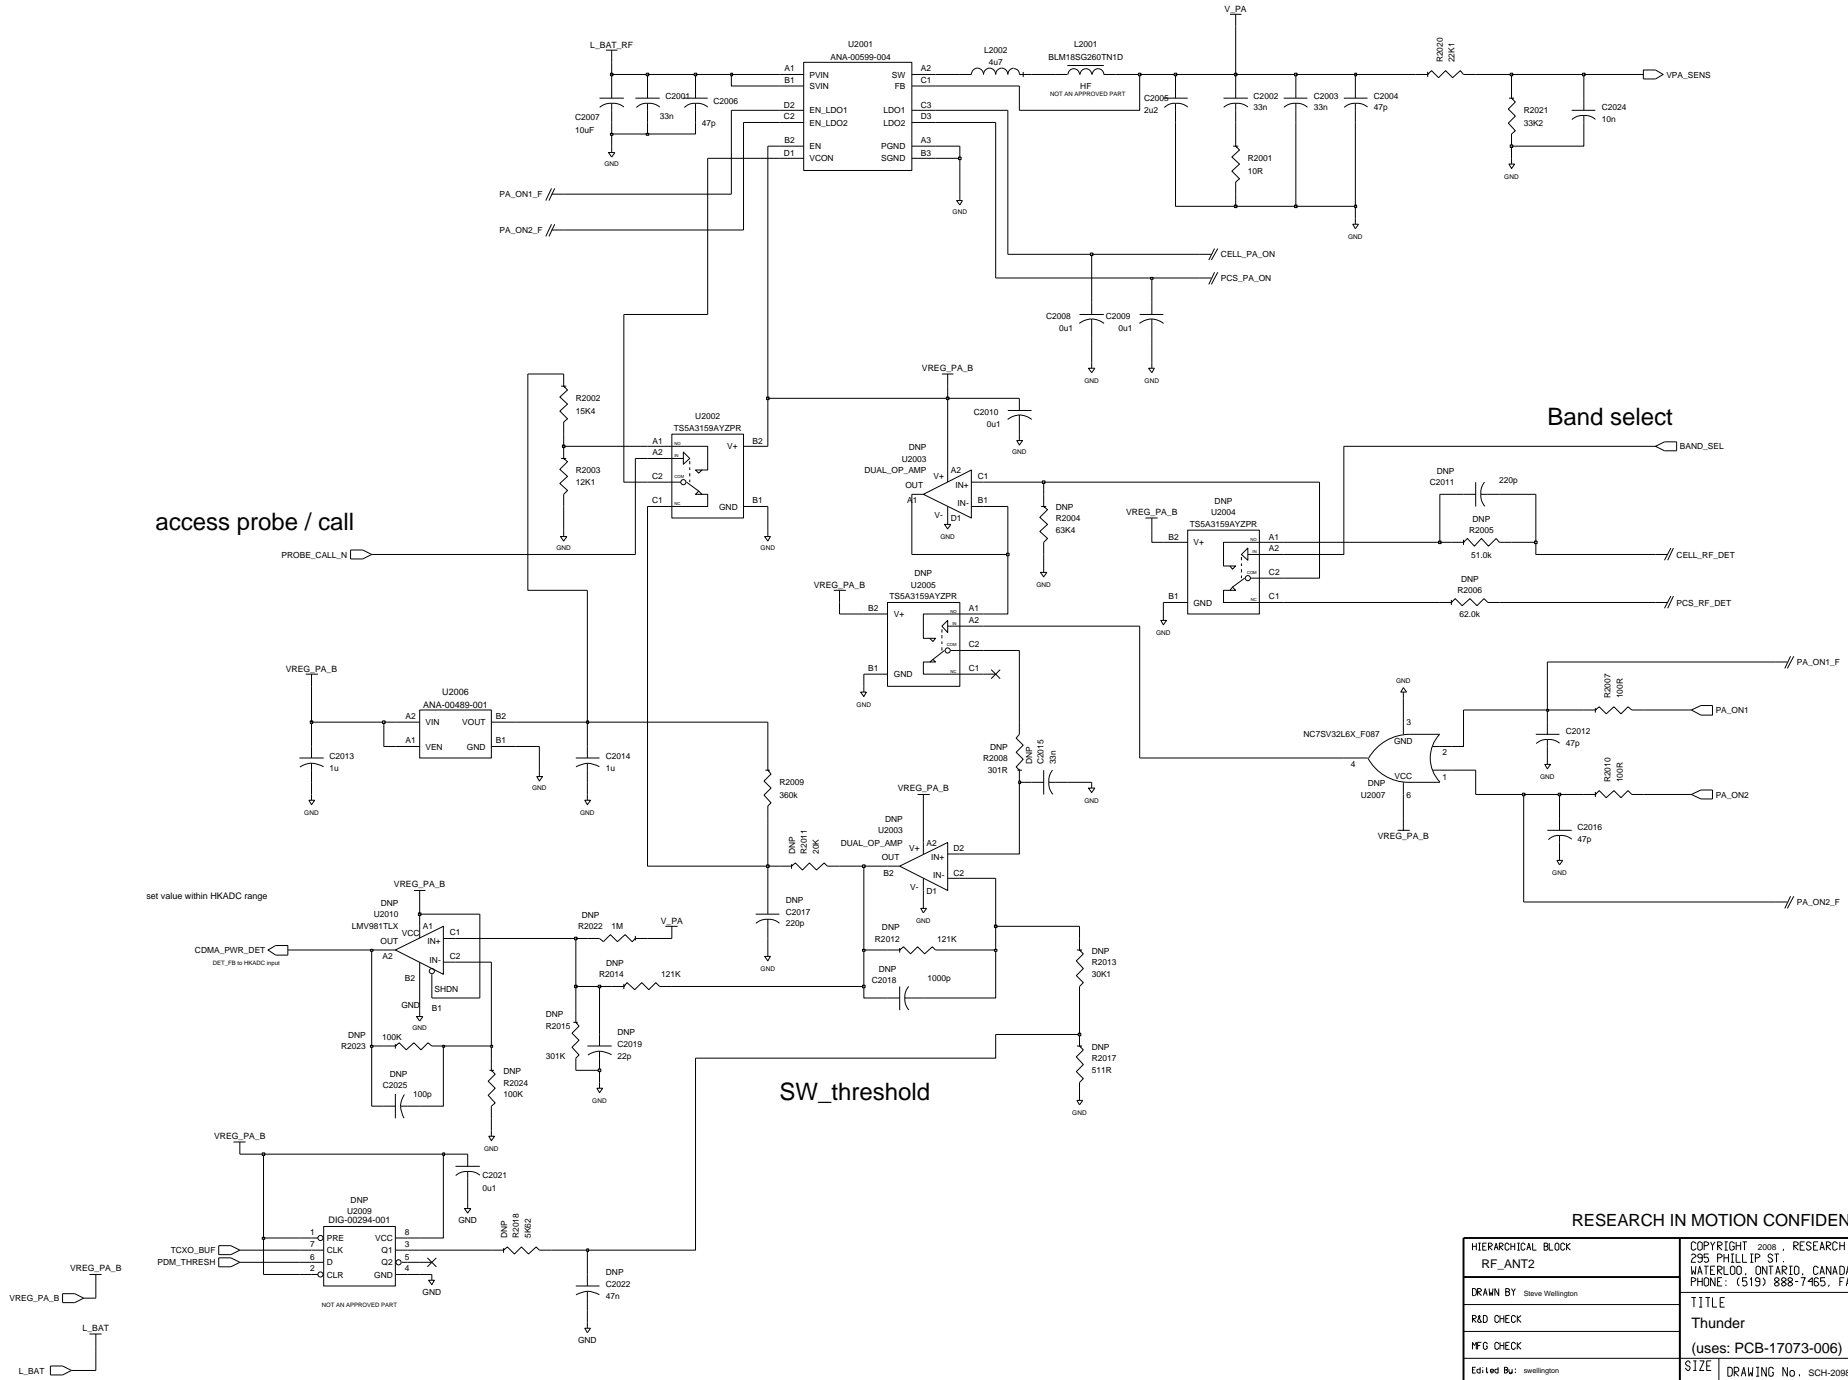

Band select

access probe / call

SW_threshold

RESEARCH IN MOTION CONFIDENTIAL

HIERARCHICAL BLOCK RF_ANT2		COPYRIGHT 2008, RESEARCH IN MOTION LIMITED 295 PHILLIP ST. WATERLOO, ONTARIO, CANADA PHONE: (519) 888-7465, FAX (519) 888-6306	
DRAWN BY Steve Wellington		TITLE Thunder	
R&D CHECK		(uses: PCB-17073-006)	
MFG CHECK		SIZE DRAWING No. SCH-20983-001	
Edi Led By: swellington		C	
Level: Ed1: Sep 29, 2008, 3:47:27 pm		REV 1	SHEET 20 OF 20